




VIRTUACTIVE

PRELIMINARY PLANS,  
NOT FOR CONSTRUCTION

# HOMESTEAD COMMUNITIES - RANCH #3 - TRANSITIONAL

Client Name  
ADDRESS

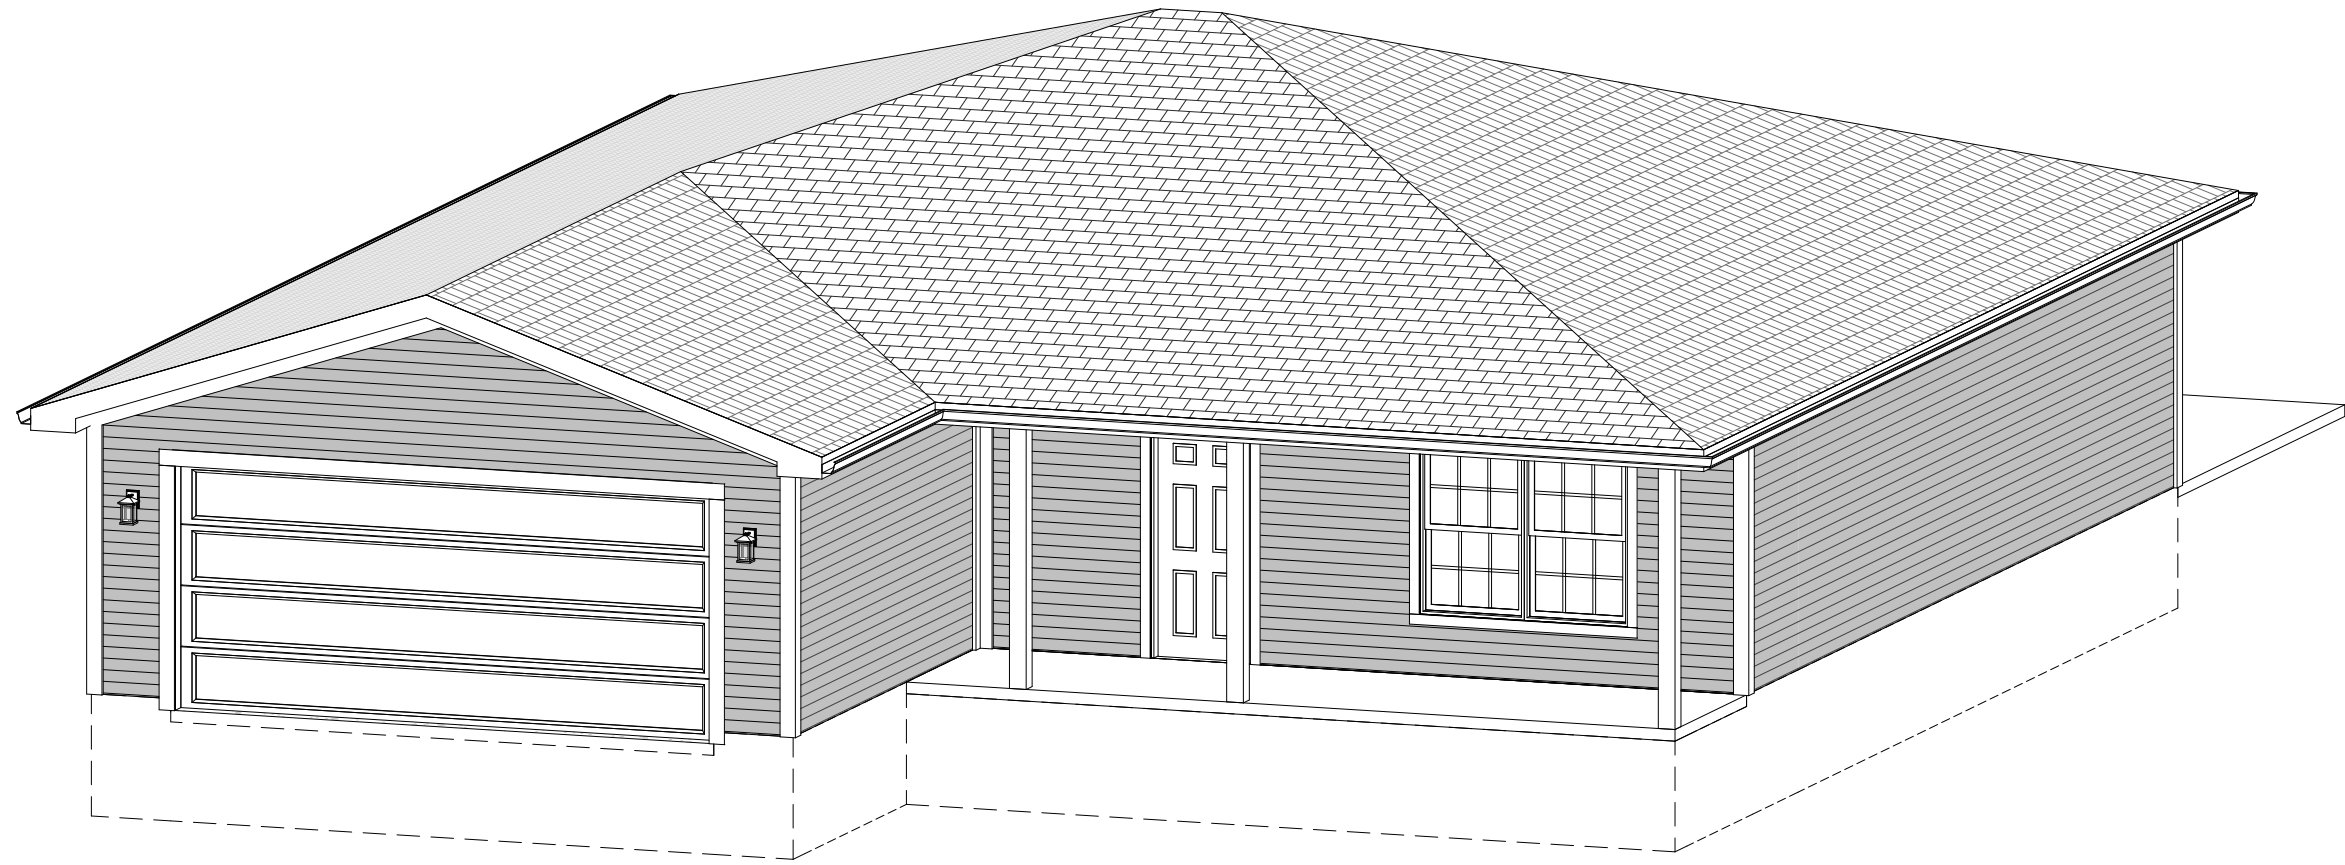

## GENERAL PLAN NOTES

These working drawings have been prepared by VirtuActive, LLC to meet building conditions and were designed under standard interpretation of the 2018 International Residential Code (IRC 2018) and the amendments adopted by the local jurisdictions. Because codes and requirements can change and may vary from jurisdiction, VirtuActive, LLC cannot warrant compliance with any specific codes or regulations. Therefore, each individual contractor, sub-contractor, and supplier on the jobsite should consult their local building official to determine the appropriateness between the plan and actual jobsite conditions and applications.

### CONCRETE and FOUNDATIONS:

Footing design assumes 1500 PSF allowable bearing pressure. Foundation wall designs assume 30 PSF equivalent hydrostatic pressure. Concrete contractor to verify soil conditions prior to concrete placement.

Re-enforcing footing as follows:

- Spread footings - as noted on plan
- Deck piers - as noted on plan

Anchor bolts must be spaced no more that 6' on center.

Once anchor bolt must be located not more than 12" from each end of the plate section

Contractors, sub-contractors, and suppliers shall be aware of and responsible for, but not limited to, the following:

- Contractors, sub-contractors, and suppliers shall verify all conditions and dimensions prior to construction and be solely responsible for any changes necessary as a result of conditional or dimensional differences.
- Contractors, sub-contractors, and suppliers shall verify all dimensions and elevations against the plan and actual site conditions.
- Calculated dimensions take precedence over scaled dimensions.
- All dimensions are from framing edge, unless otherwise noted.

### STRUCTURAL and FRAMING:

All structural member types, sizes, and spans shall be verified by the contractor, sub-contractor, and/or supplier.

All additional structural members required for specific framing techniques shall be sized by the contractor, sub-contractor, and/or supplier.

All steel pipe columns shall be 3.5", unless otherwise noted.

Ceiling joists, rafters and /or roof trusses shown per plan. Sizing, spans reinforcement locations, and depth to be verified by the contractor, sub-contractor, and/or supplier.

Provide bridging as required by code.

All perimeter headers over openings to be (2) 2x12, unless otherwise noted.

Provide double cripple studs under all LVL headers.

Wind bracing to be CS-WSP unless specified otherwise.

Penetrations though any structural member must be verified by engineer and/or structural supplier.

## TABLE OF CONTENTS

|        |                       |
|--------|-----------------------|
| PAGE 1 | COVER PAGE            |
| PAGE 2 | FRONT AND REAR VIEWS  |
| PAGE 3 | LEFT AND RIGHT VIEWS  |
| PAGE 4 | 3D ORTHOGRAPHIC VIEWS |
| PAGE 5 | FOUNDATION PLAN       |
| PAGE 6 | MAIN FLOOR PLAN       |
| PAGE 7 | ROOF PLAN             |
| PAGE 8 | MAIN ELECTRICAL PLAN  |
| PAGE 9 | MAIN LEVEL AREA PLAN  |

### FINISHED SQ. FT.

|            |         |
|------------|---------|
| MAIN LEVEL | 1502 SF |
| TOTALS     | 1502 SF |

### UNFINISHED SQ. FT.

|               |        |
|---------------|--------|
| COVERED STOOP | 138 SF |
| GARAGE        | 414 SF |
| PATIO         | 140 SF |
| TOTALS        | 692 SF |

These drawings are the proprietary work product and property of VirtuActive, LLC developed for the exclusive use of VirtuActive, LLC. Use of these drawings and concepts contained herein without the written permission of VirtuActive, LLC is prohibited. The contractor, sub-contractor, supplier, and/or homeowners shall verify all dimensions and elevations against the plan and actual site conditions. The contractor, sub-contractor, supplier, and/or homeowners must check all dimensions and other details prior to construction and be solely responsible for any changes necessary as a result of conditional or dimensional differences. The contractor, sub-contractor, and supplier are responsible for all code and regulatory requirements. The contractor, sub-contractor, and supplier are responsible for negligence on the jobsite due to lack of knowledge or lack of plan detail from the sub-structural members, site suitability, and dimensions shall be verified by the contractor, sub-contractor, supplier, and/or owner.

PROJECT LOCATION:

ADDRESS

PREPARED FOR:

HOMESTEAD COMMUNITIES  
RANCH #3  
Client Name



DATE:

10/1/2025


SHEET:

PAGE 1




VIRTUACTIVE

PRELIMINARY PLANS,  
NOT FOR CONSTRUCTION

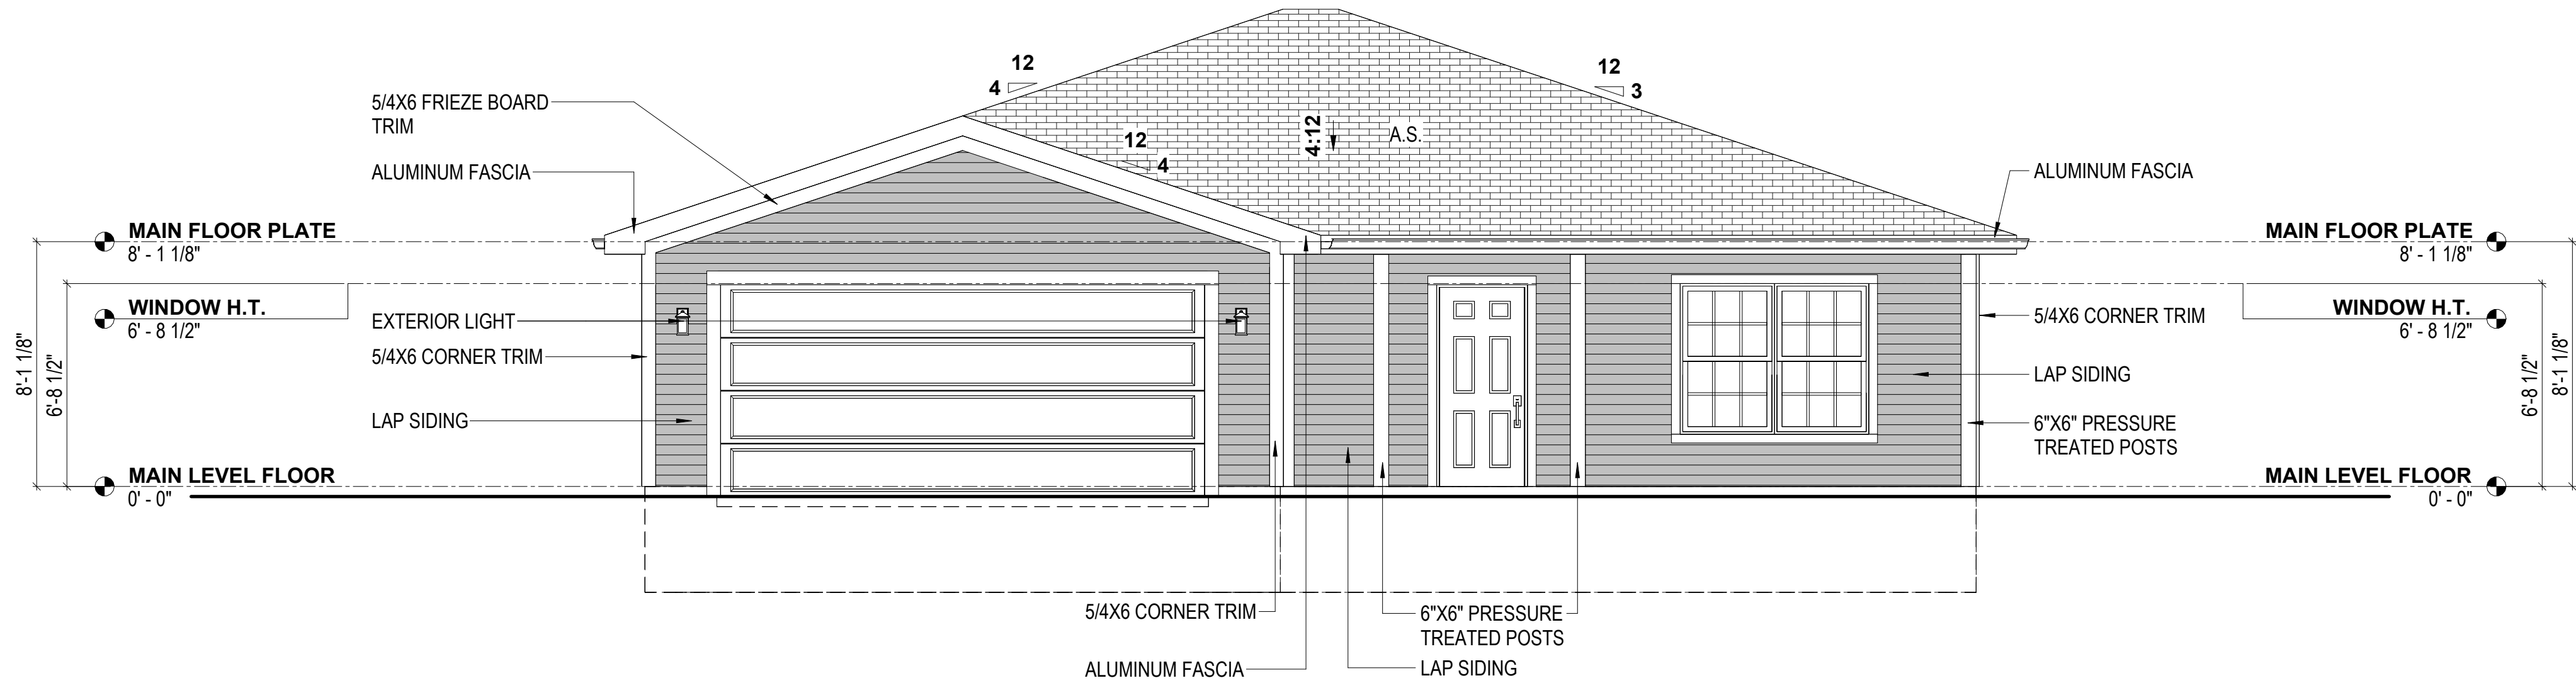

1  
**TRANSITIONAL  
FRONT VIEW**  
1/4" = 1'-0"

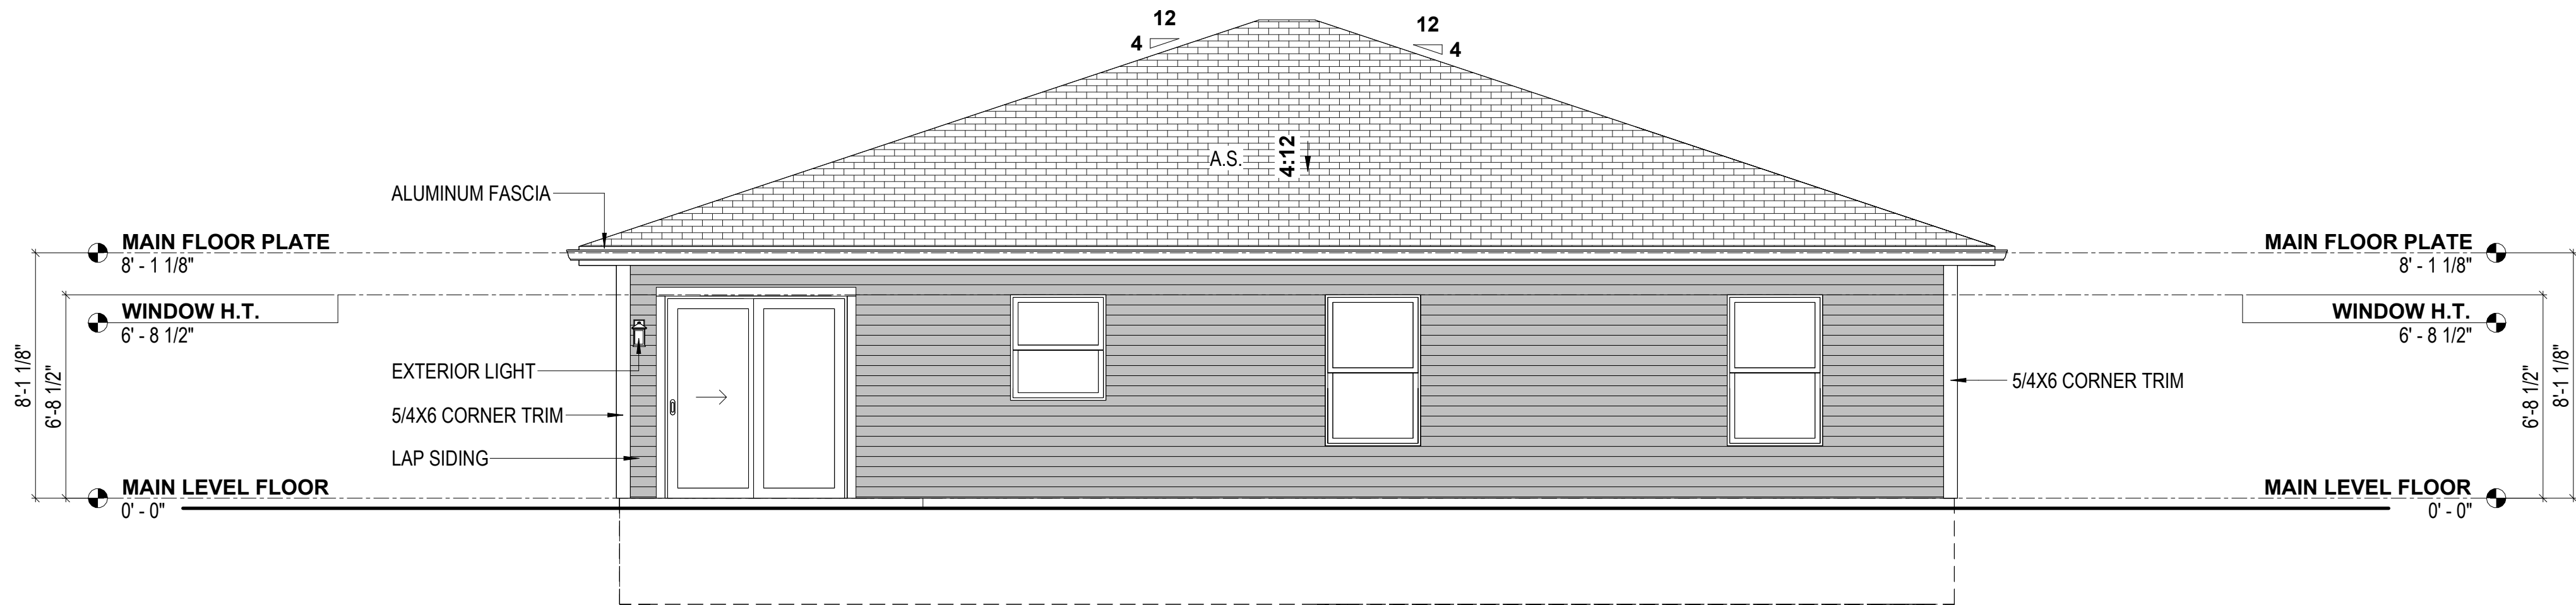

2  
**TRANSITIONAL  
REAR VIEW**  
1/4" = 1'-0"


These drawings are the property of VirtuActive, LLC and are not to be reproduced or used in any way without the written permission of VirtuActive, LLC. The contractor, sub-contractors, suppliers, and for homeowners shall verify all dimensions and materials shown on these drawings. The contractor, sub-contractors, suppliers, and for homeowners shall verify all dimensions and materials shown on these drawings. The contractor, sub-contractors, suppliers, and for homeowners shall verify all dimensions and materials shown on these drawings. The contractor, sub-contractors, suppliers, and for homeowners shall verify all dimensions and materials shown on these drawings.

PROJECT LOCATION:  
ADDRESS


PREPARED FOR:  
HOMESTEAD COMMUNITIES  
RANCH #3  
Client Name

VIRTUACTIVE  
VirtuActive - 3D Drafting & Design  
1414 North 20th Street, Suite 2, Elkhorn, NE 68022  
www.VirtuActive.com | 402.979.8100

DATE:  
10/1/2025  
SHEET:  
PAGE 2

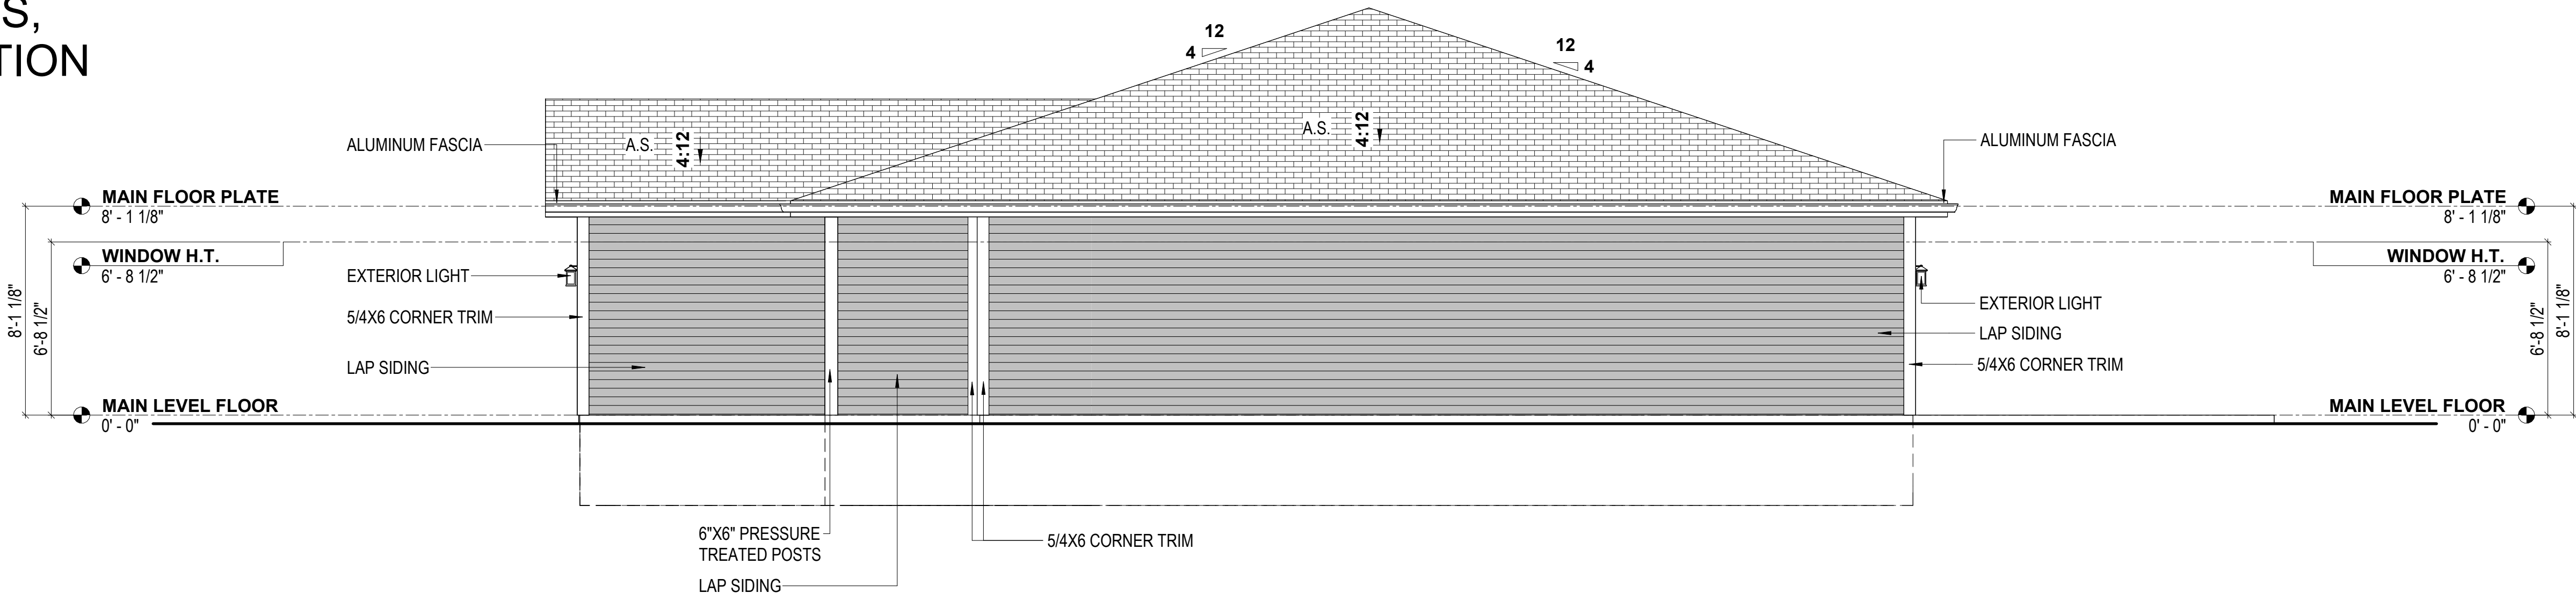

1  
1/4" = 1'-0"

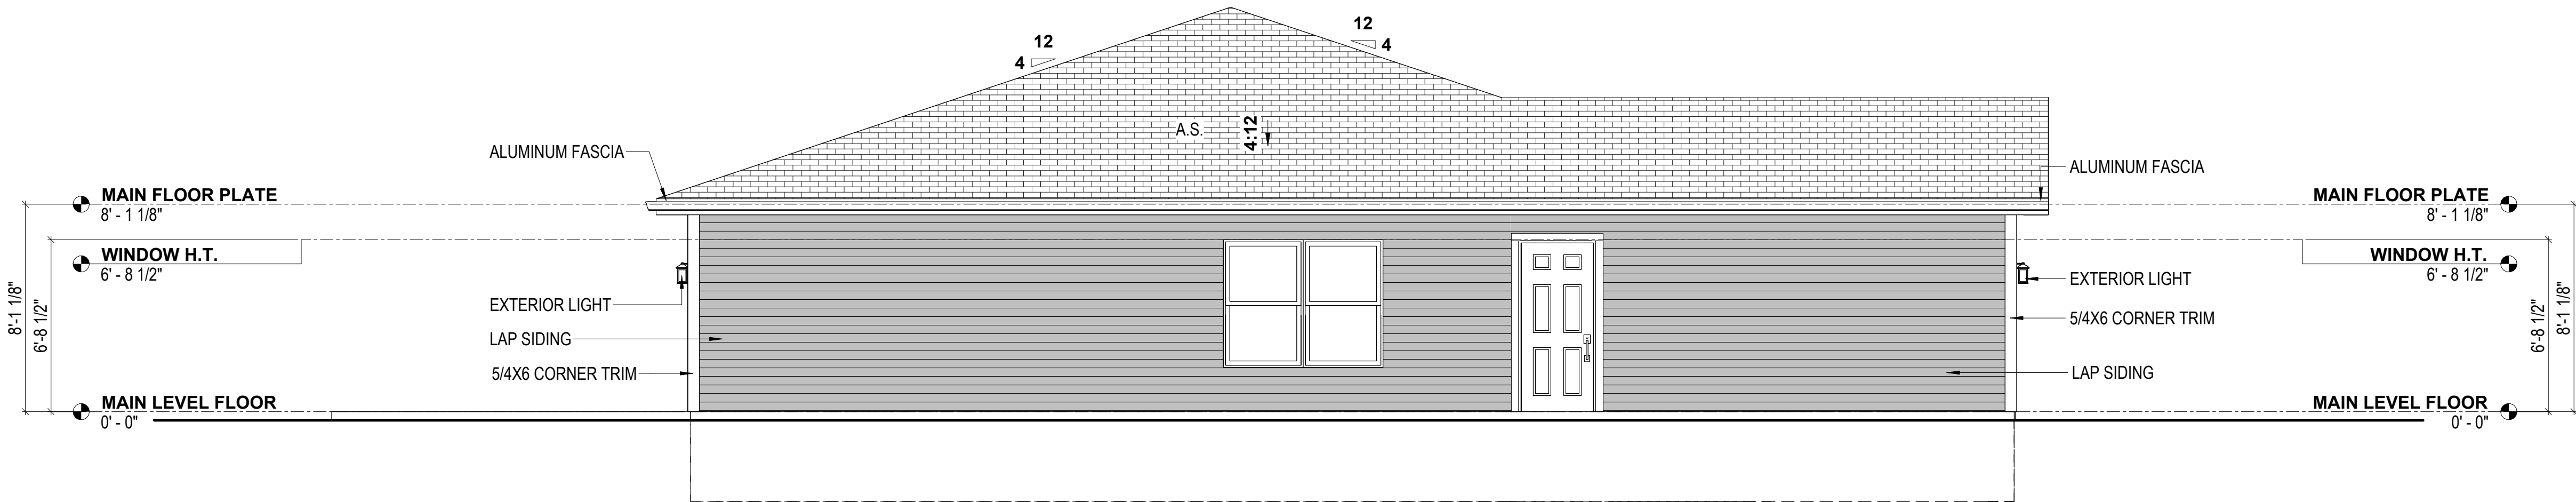

2  
1/4" = 1'-0"

These drawings are the property of VirtuActive, LLC and are not to be reproduced or used in any manner without the written permission of VirtuActive, LLC. Use of these drawings and concepts contained herein without the written permission of VirtuActive, LLC is prohibited. The contractor, sub-contractor, supplier, and/or homeowner shall verify all dimensions and materials shown on these drawings. The contractor, sub-contractor, supplier, and/or homeowner must check all dimensions and other details prior to construction and be solely responsible for any discrepancies. VirtuActive, LLC and its representatives are not responsible for any errors or omissions on these drawings due to lack of knowledge or lack of detail from the sub-contractor, supplier, and/or homeowner. Dimensions shall be verified by the contractor, sub-contractor, supplier, and/or owner.

| REVISION TABLE | DESCRIPTION |
|----------------|-------------|
| NUMBER         | DATE        |
|                |             |
|                |             |
| PROJECT LOCATION: |
|-------------------|
| ADDRESS           |

| PREPARED FOR:         |
|-----------------------|
| HOMESTEAD COMMUNITIES |
| RANCH #3              |
| Client Name           |



VIRTUACTIVE

PRELIMINARY PLANS,  
NOT FOR CONSTRUCTION

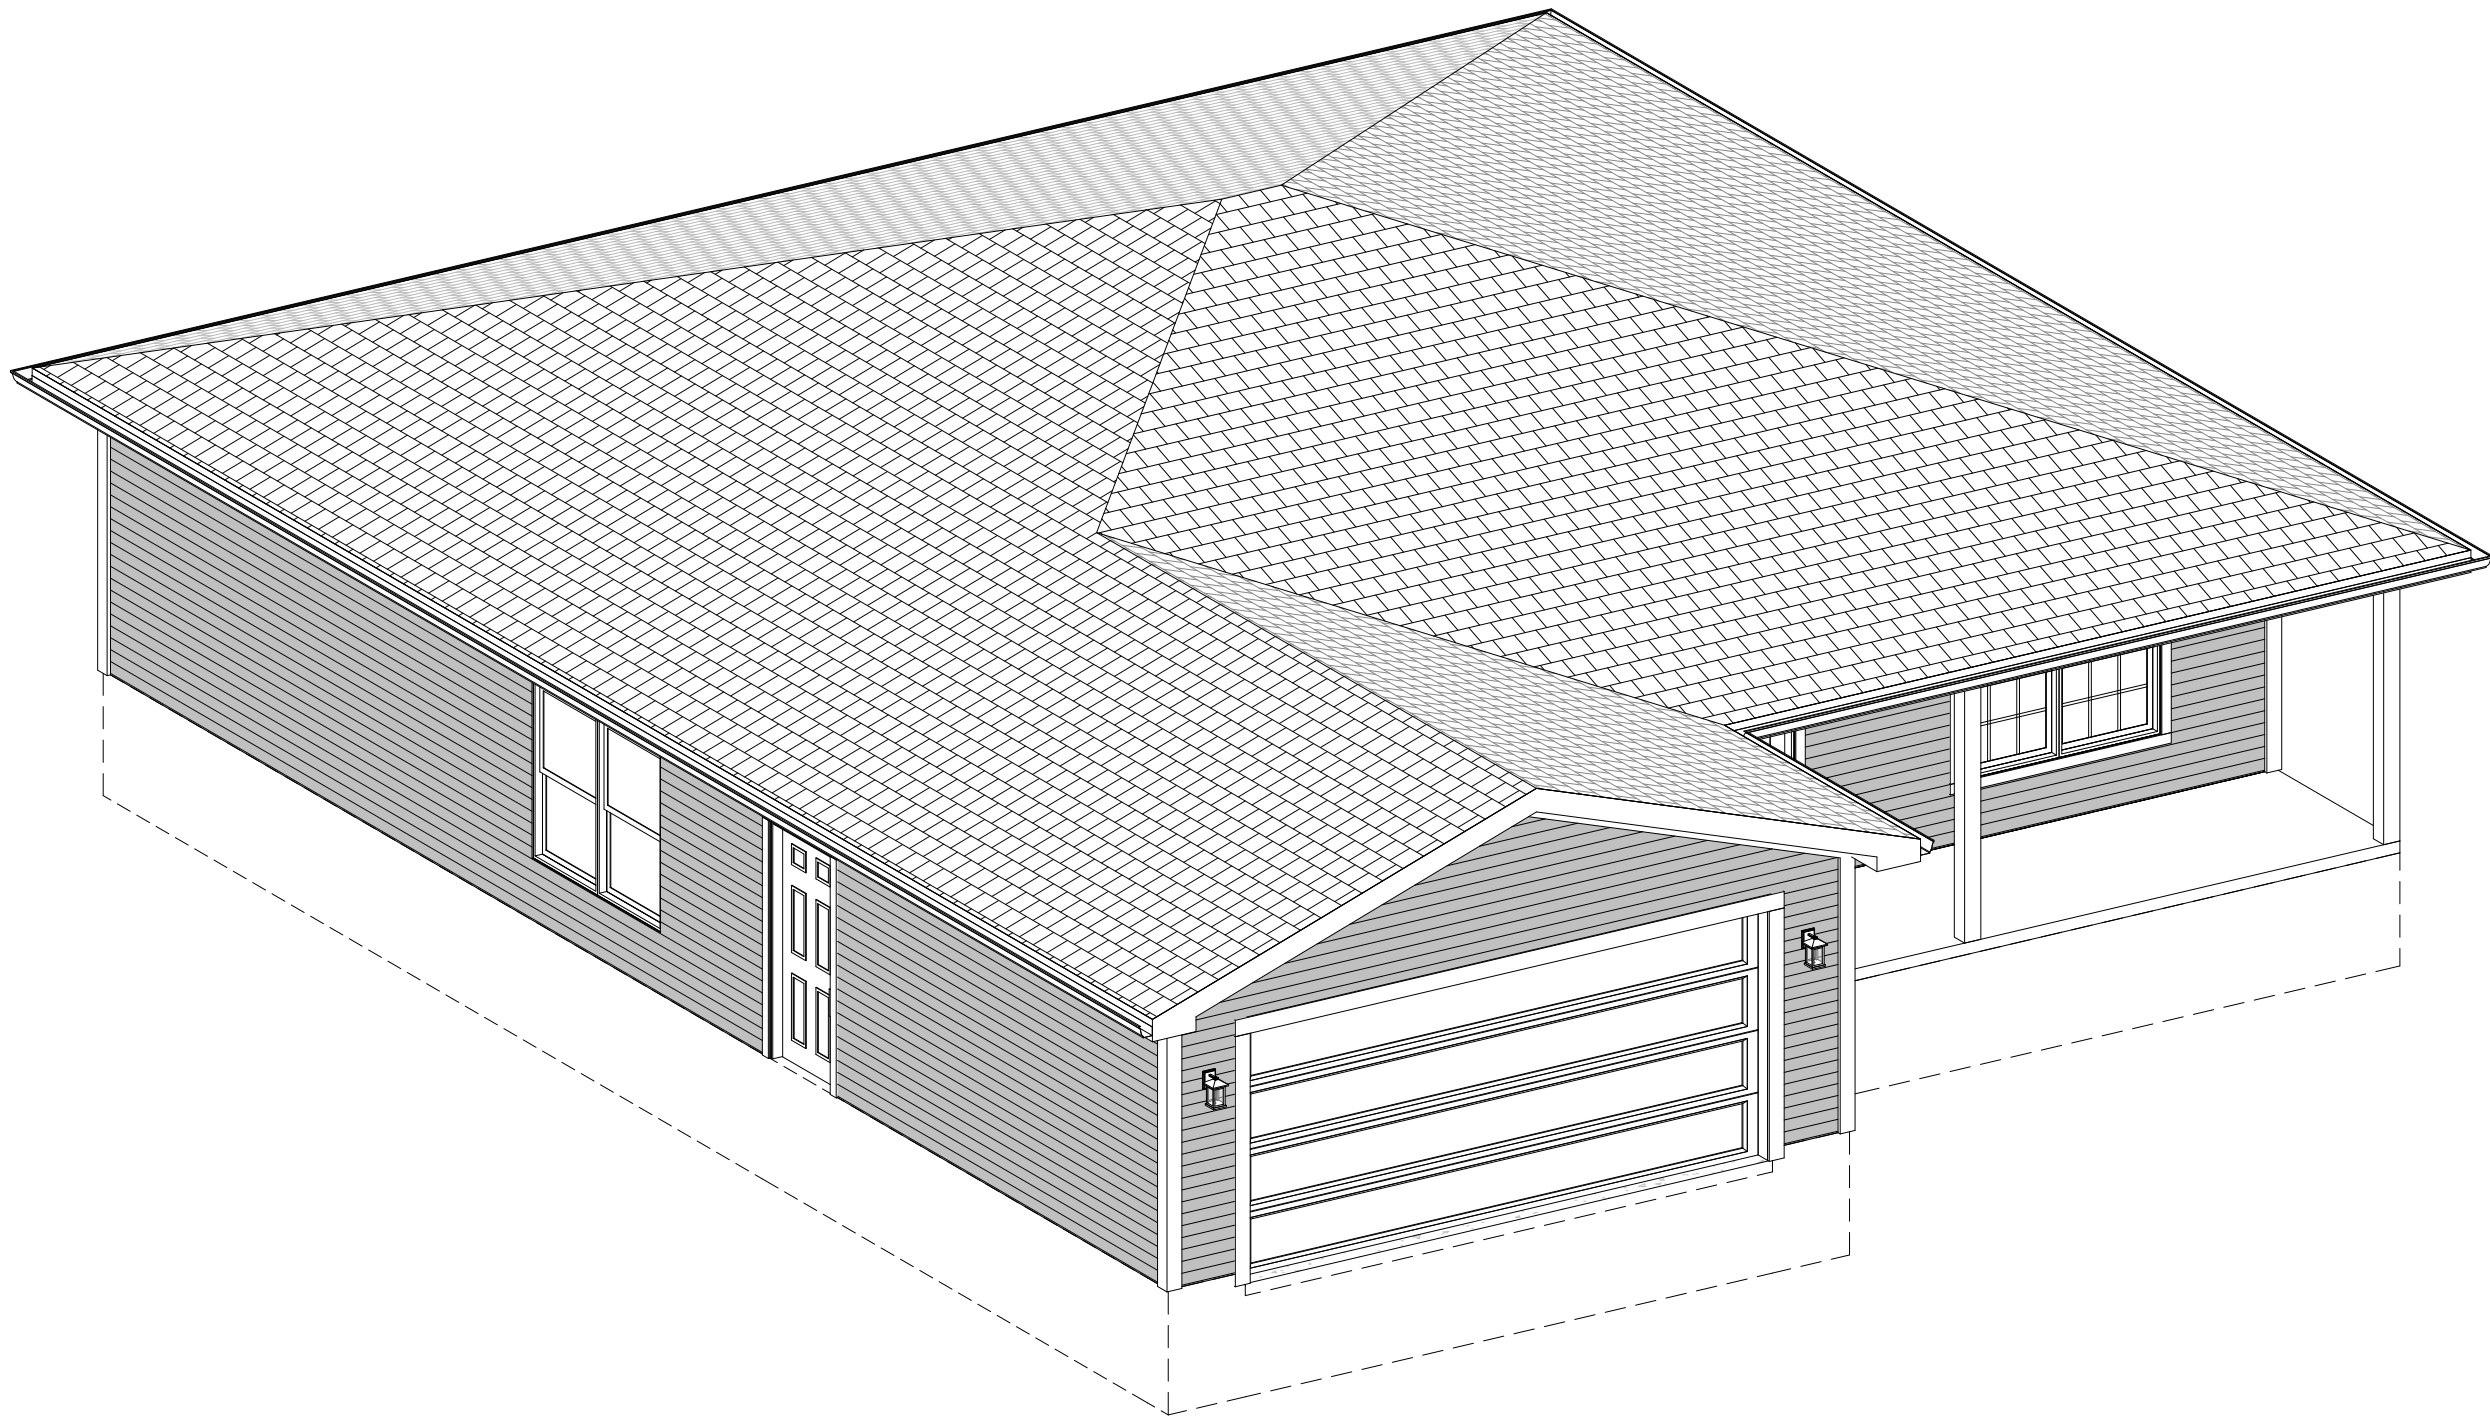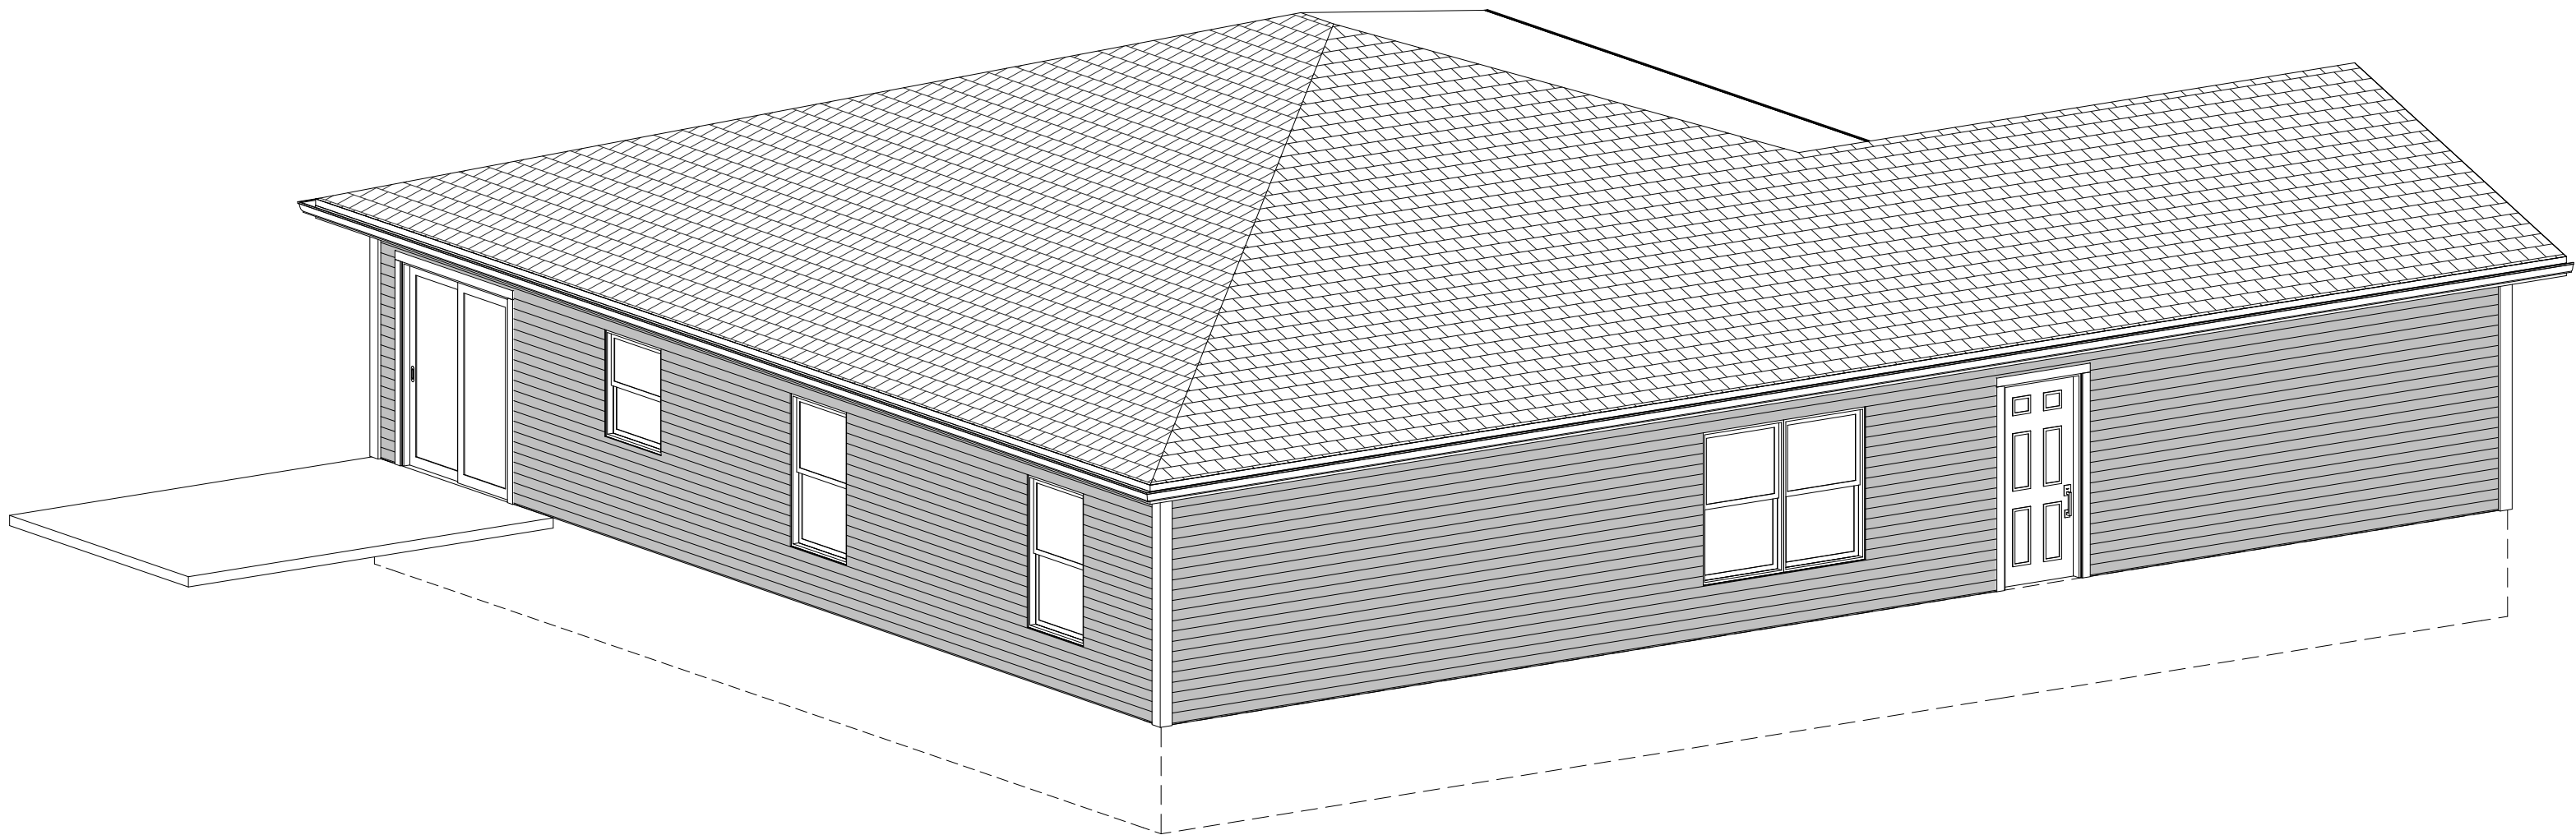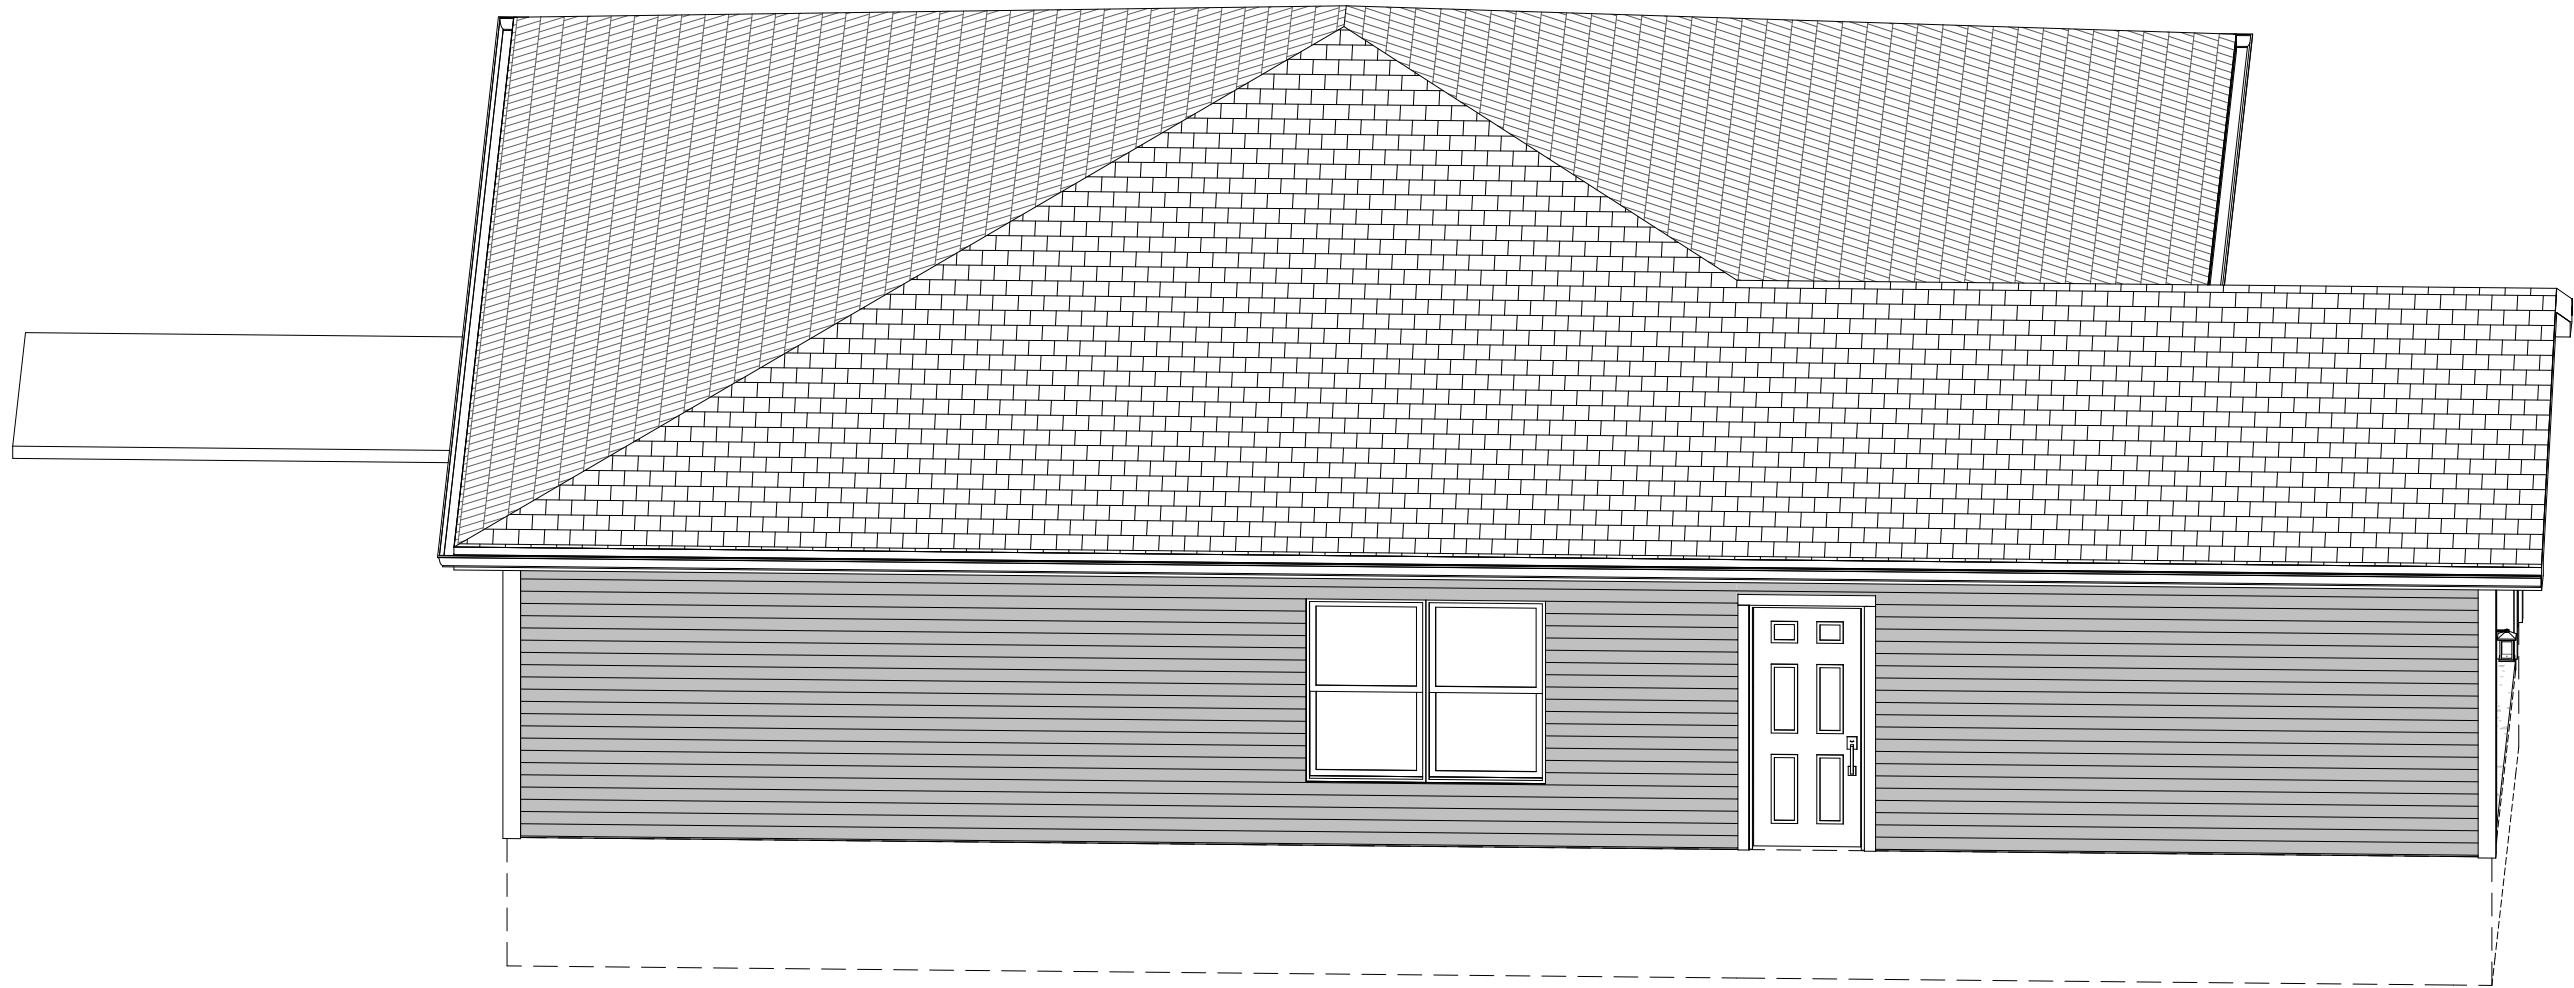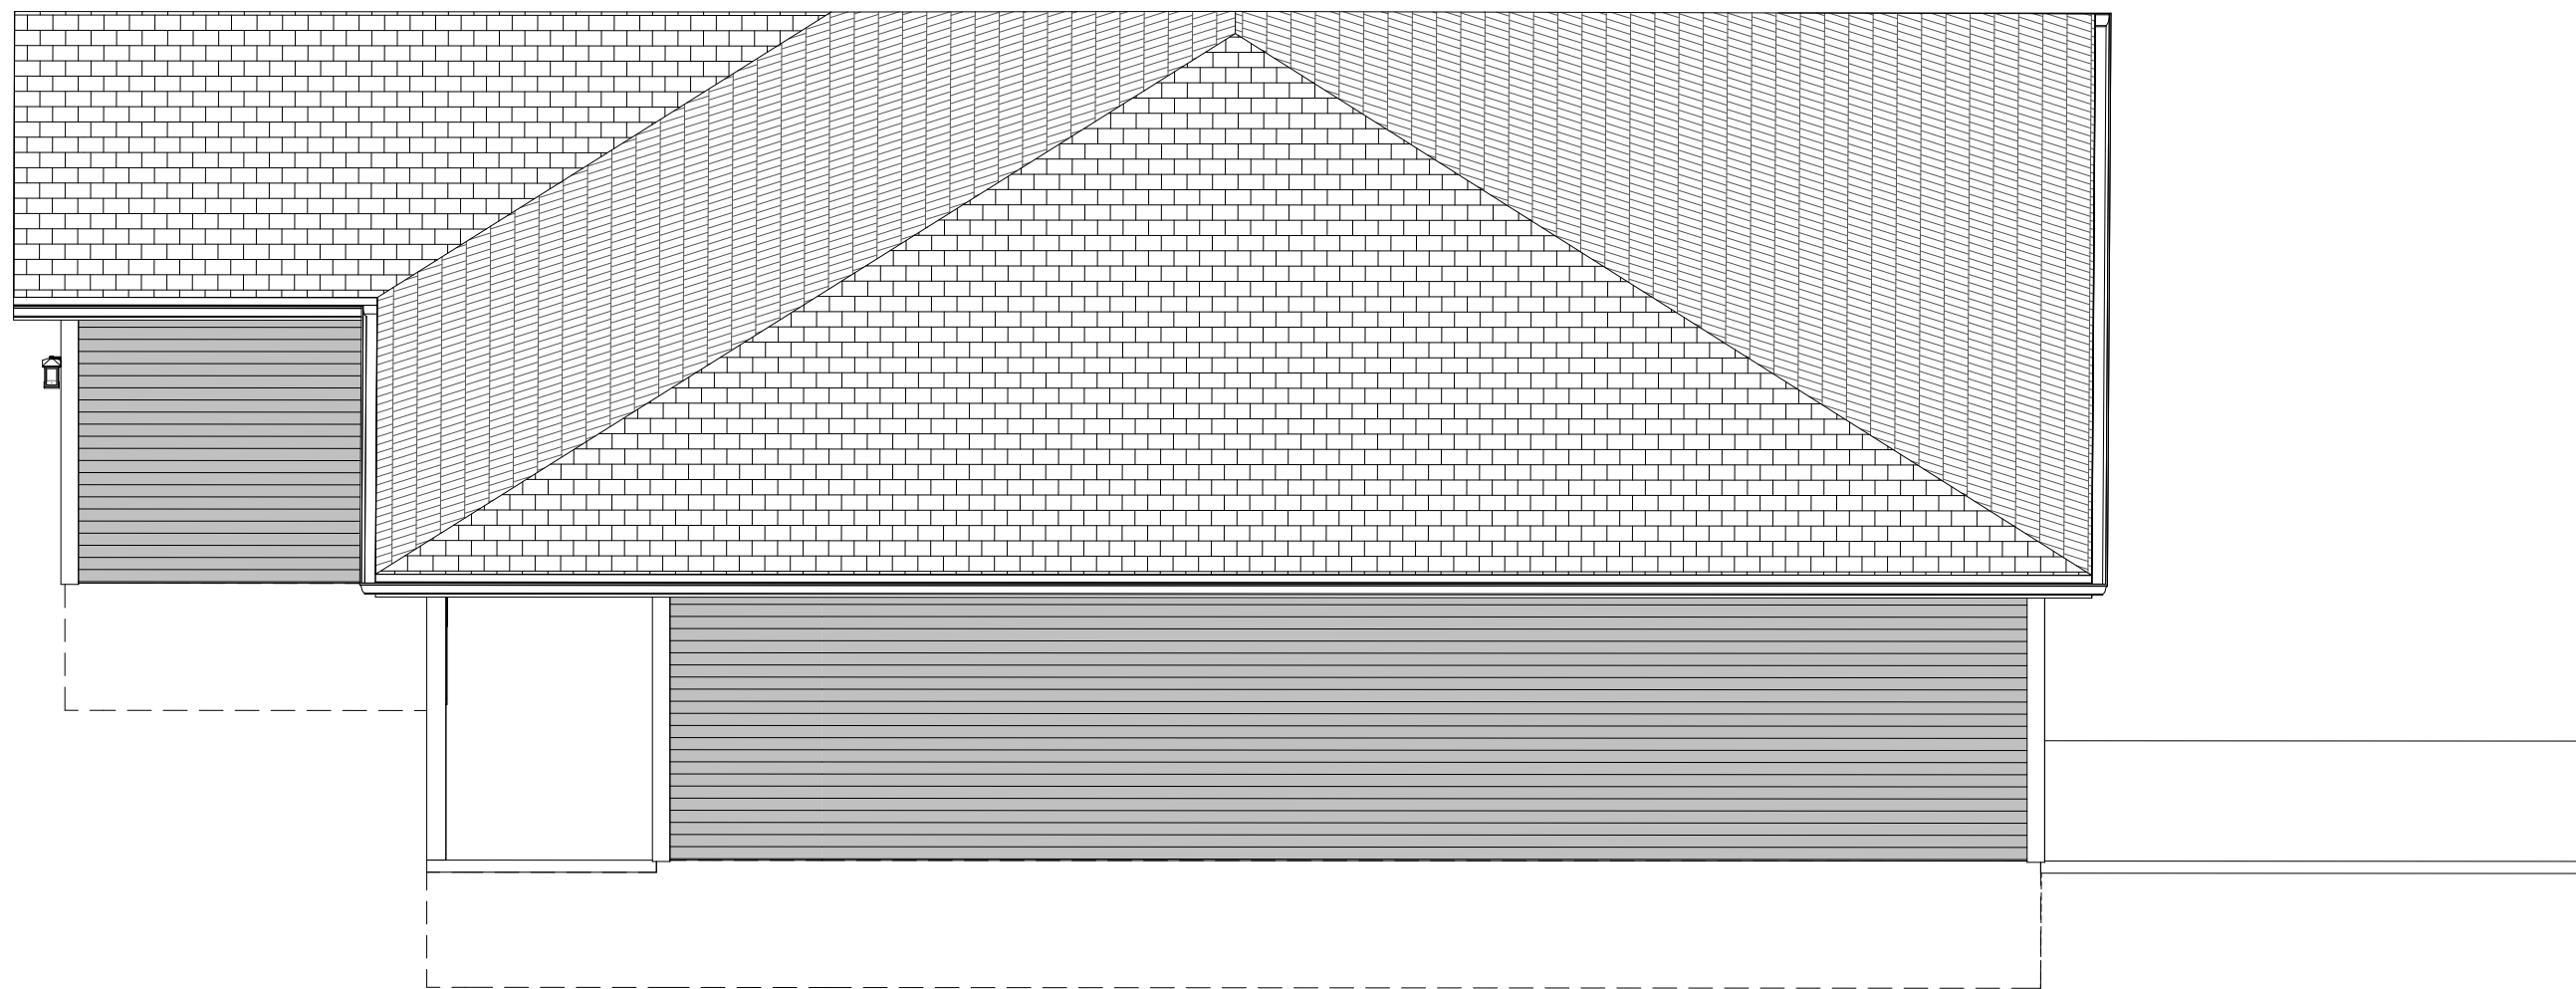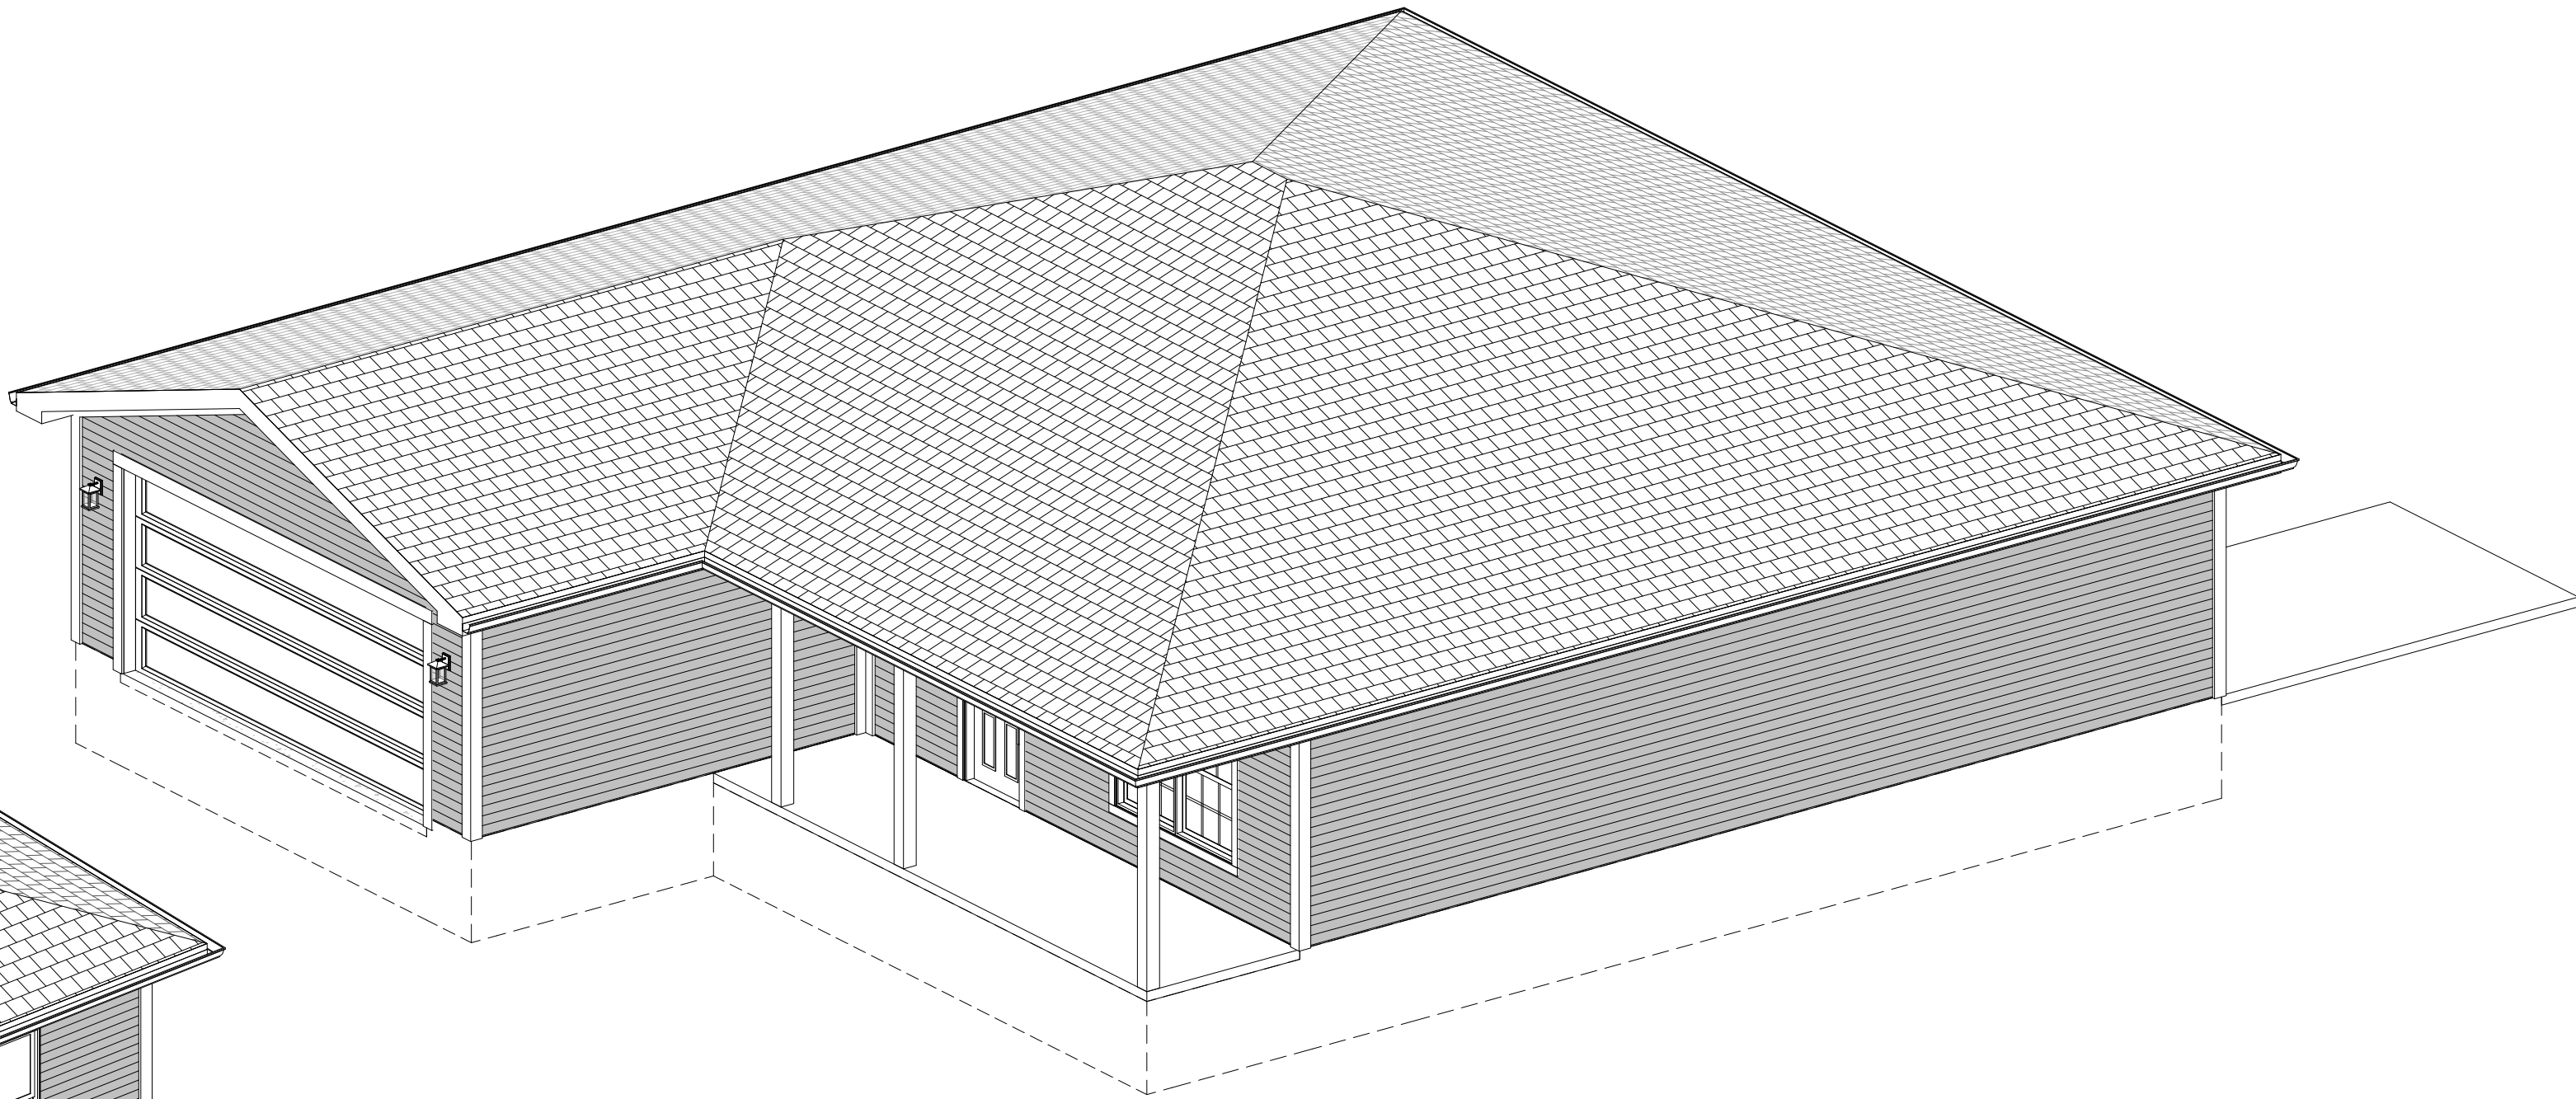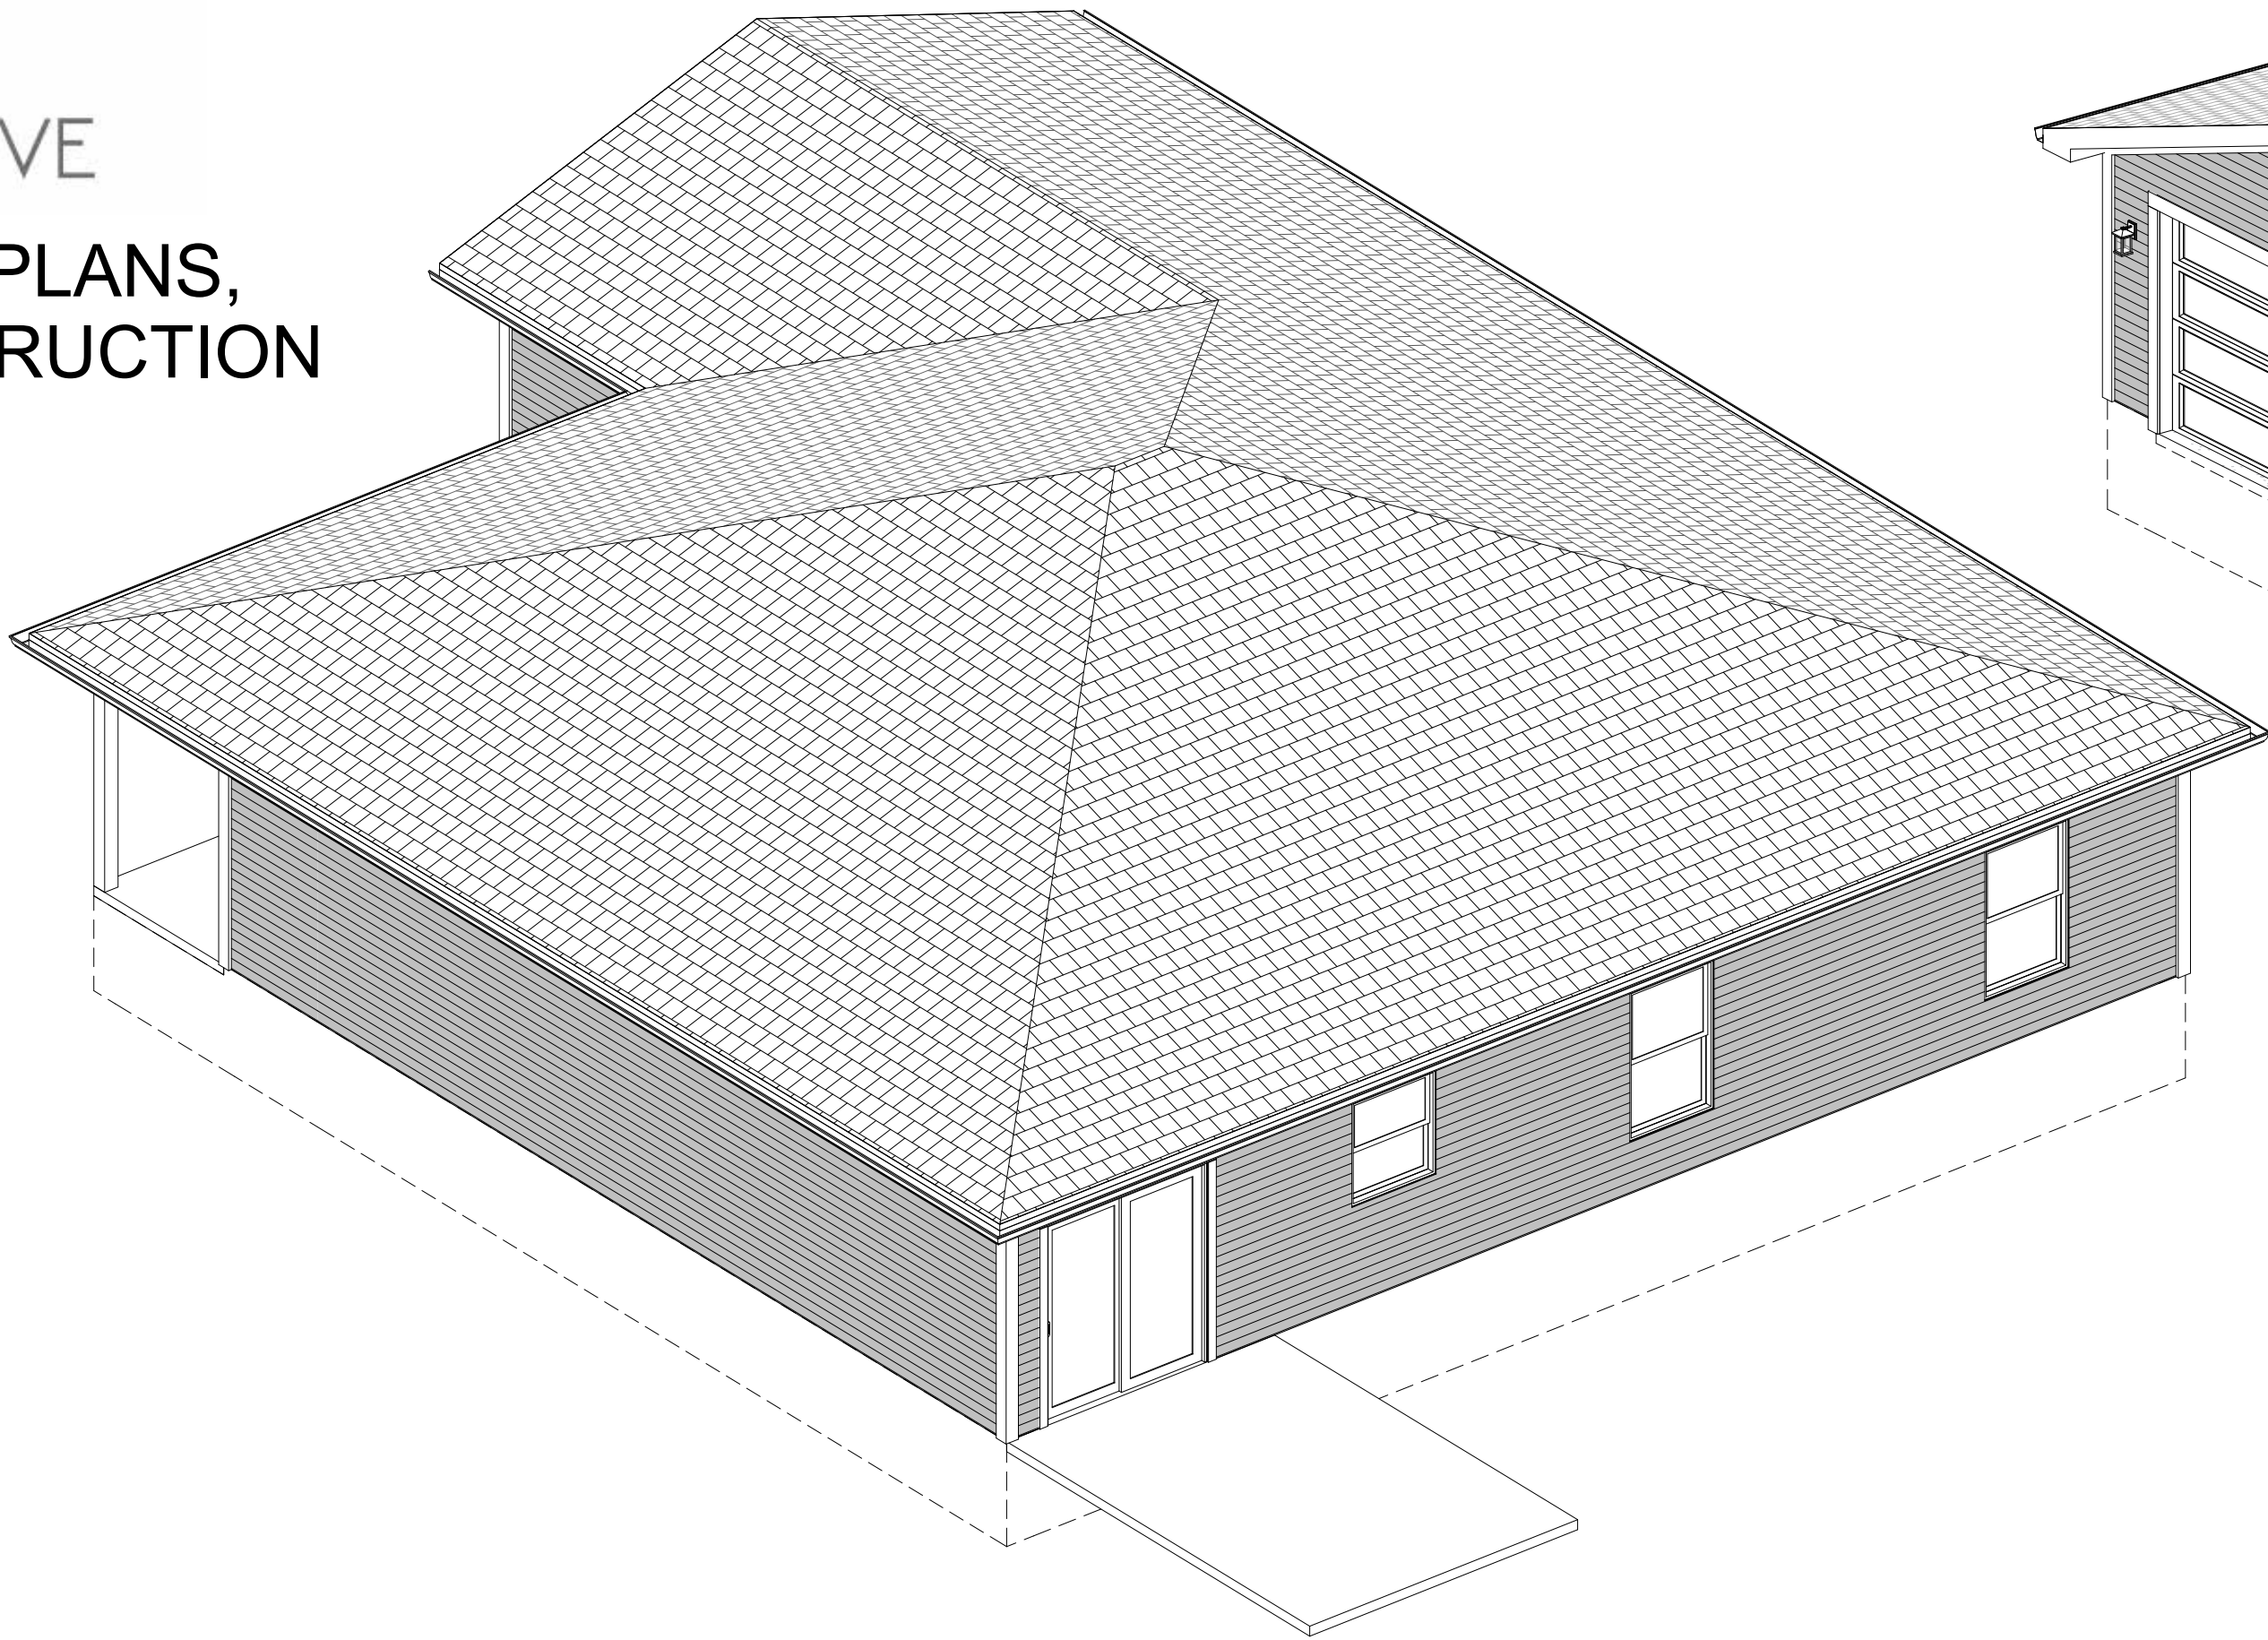

| NUMBER | DATE | REVISION TABLE | REVISION BY | DESCRIPTION |
|--------|------|----------------|-------------|-------------|
|        |      |                |             |             |
|        |      |                |             |             |
|        |      |                |             |             |
|        |      |                |             |             |
|        |      |                |             |             |

These drawings are the property of VirtuActive, LLC and are not to be used for any other project without the written permission of VirtuActive, LLC. Use of these drawings and concepts contained herein without the written permission of VirtuActive, LLC is prohibited. The contractor, sub-contractors, suppliers, and/or homeowners shall verify all dimensions and materials shown on these drawings. The contractor, sub-contractors, suppliers, and/or homeowners must check all dimensions and other details prior to construction and be solely responsible for any discrepancies. VirtuActive, LLC is not responsible for any errors or omissions in these drawings. For negligence on the part of the contractor, sub-contractor, supplier, or homeowner, VirtuActive, LLC shall not be held liable. The contractor, sub-contractor, supplier, and/or homeowner shall be held responsible for any errors or omissions in these drawings.

PROJECT LOCATION:  
ADDRESS

PREPARED FOR:  
HOMESTEAD COMMUNITIES  
RANCH #3  
Client Name





VIRTUACTIVE


PRELIMINARY PLANS,  
NOT FOR CONSTRUCTION

FOUNDATION & FRAMING NOTES

1. All structural members and framing members shall be confirmed by contractor, sub-contractor, and/or supplier for size, spacing, and species to verify they meet local code requirements.
2. All exterior framing dimensions are to exterior face of sheathing.
3. All interior framing dimensions to framing edge, unless otherwise noted.
4. 12" x Min. 36" below grade poured concrete foundation walls, unless otherwise noted.
5. 2x6 exterior and 2x4 interior walls, unless otherwise noted.
6. All exterior headers shall be (2) 2x12, unless otherwise noted.
7. Door sizes noted as feet and inches.
8. Window sizes noted as inches. Contractor, sub-contractor, and/or suppliers to confirm window openings for egress, min. light, min. height, and ventilation requirements. Contractor and/or sub-contractor to go off of supplier provided rough opening sheet for all rough openings & sizes.
9. Ceiling Heights: 8'-0" Main Floor.
10. Allow for at least 3.5" from interior door rough openings to wall.
11. All angled walls are 45°, unless otherwise noted.
12. All centerline dimensions for fixtures should be double checked for field accuracy.
13. Wall bracing method = CS-WSP

TRANSITIONAL  
FOUNDATION PLAN

1/4" = 1'-0"

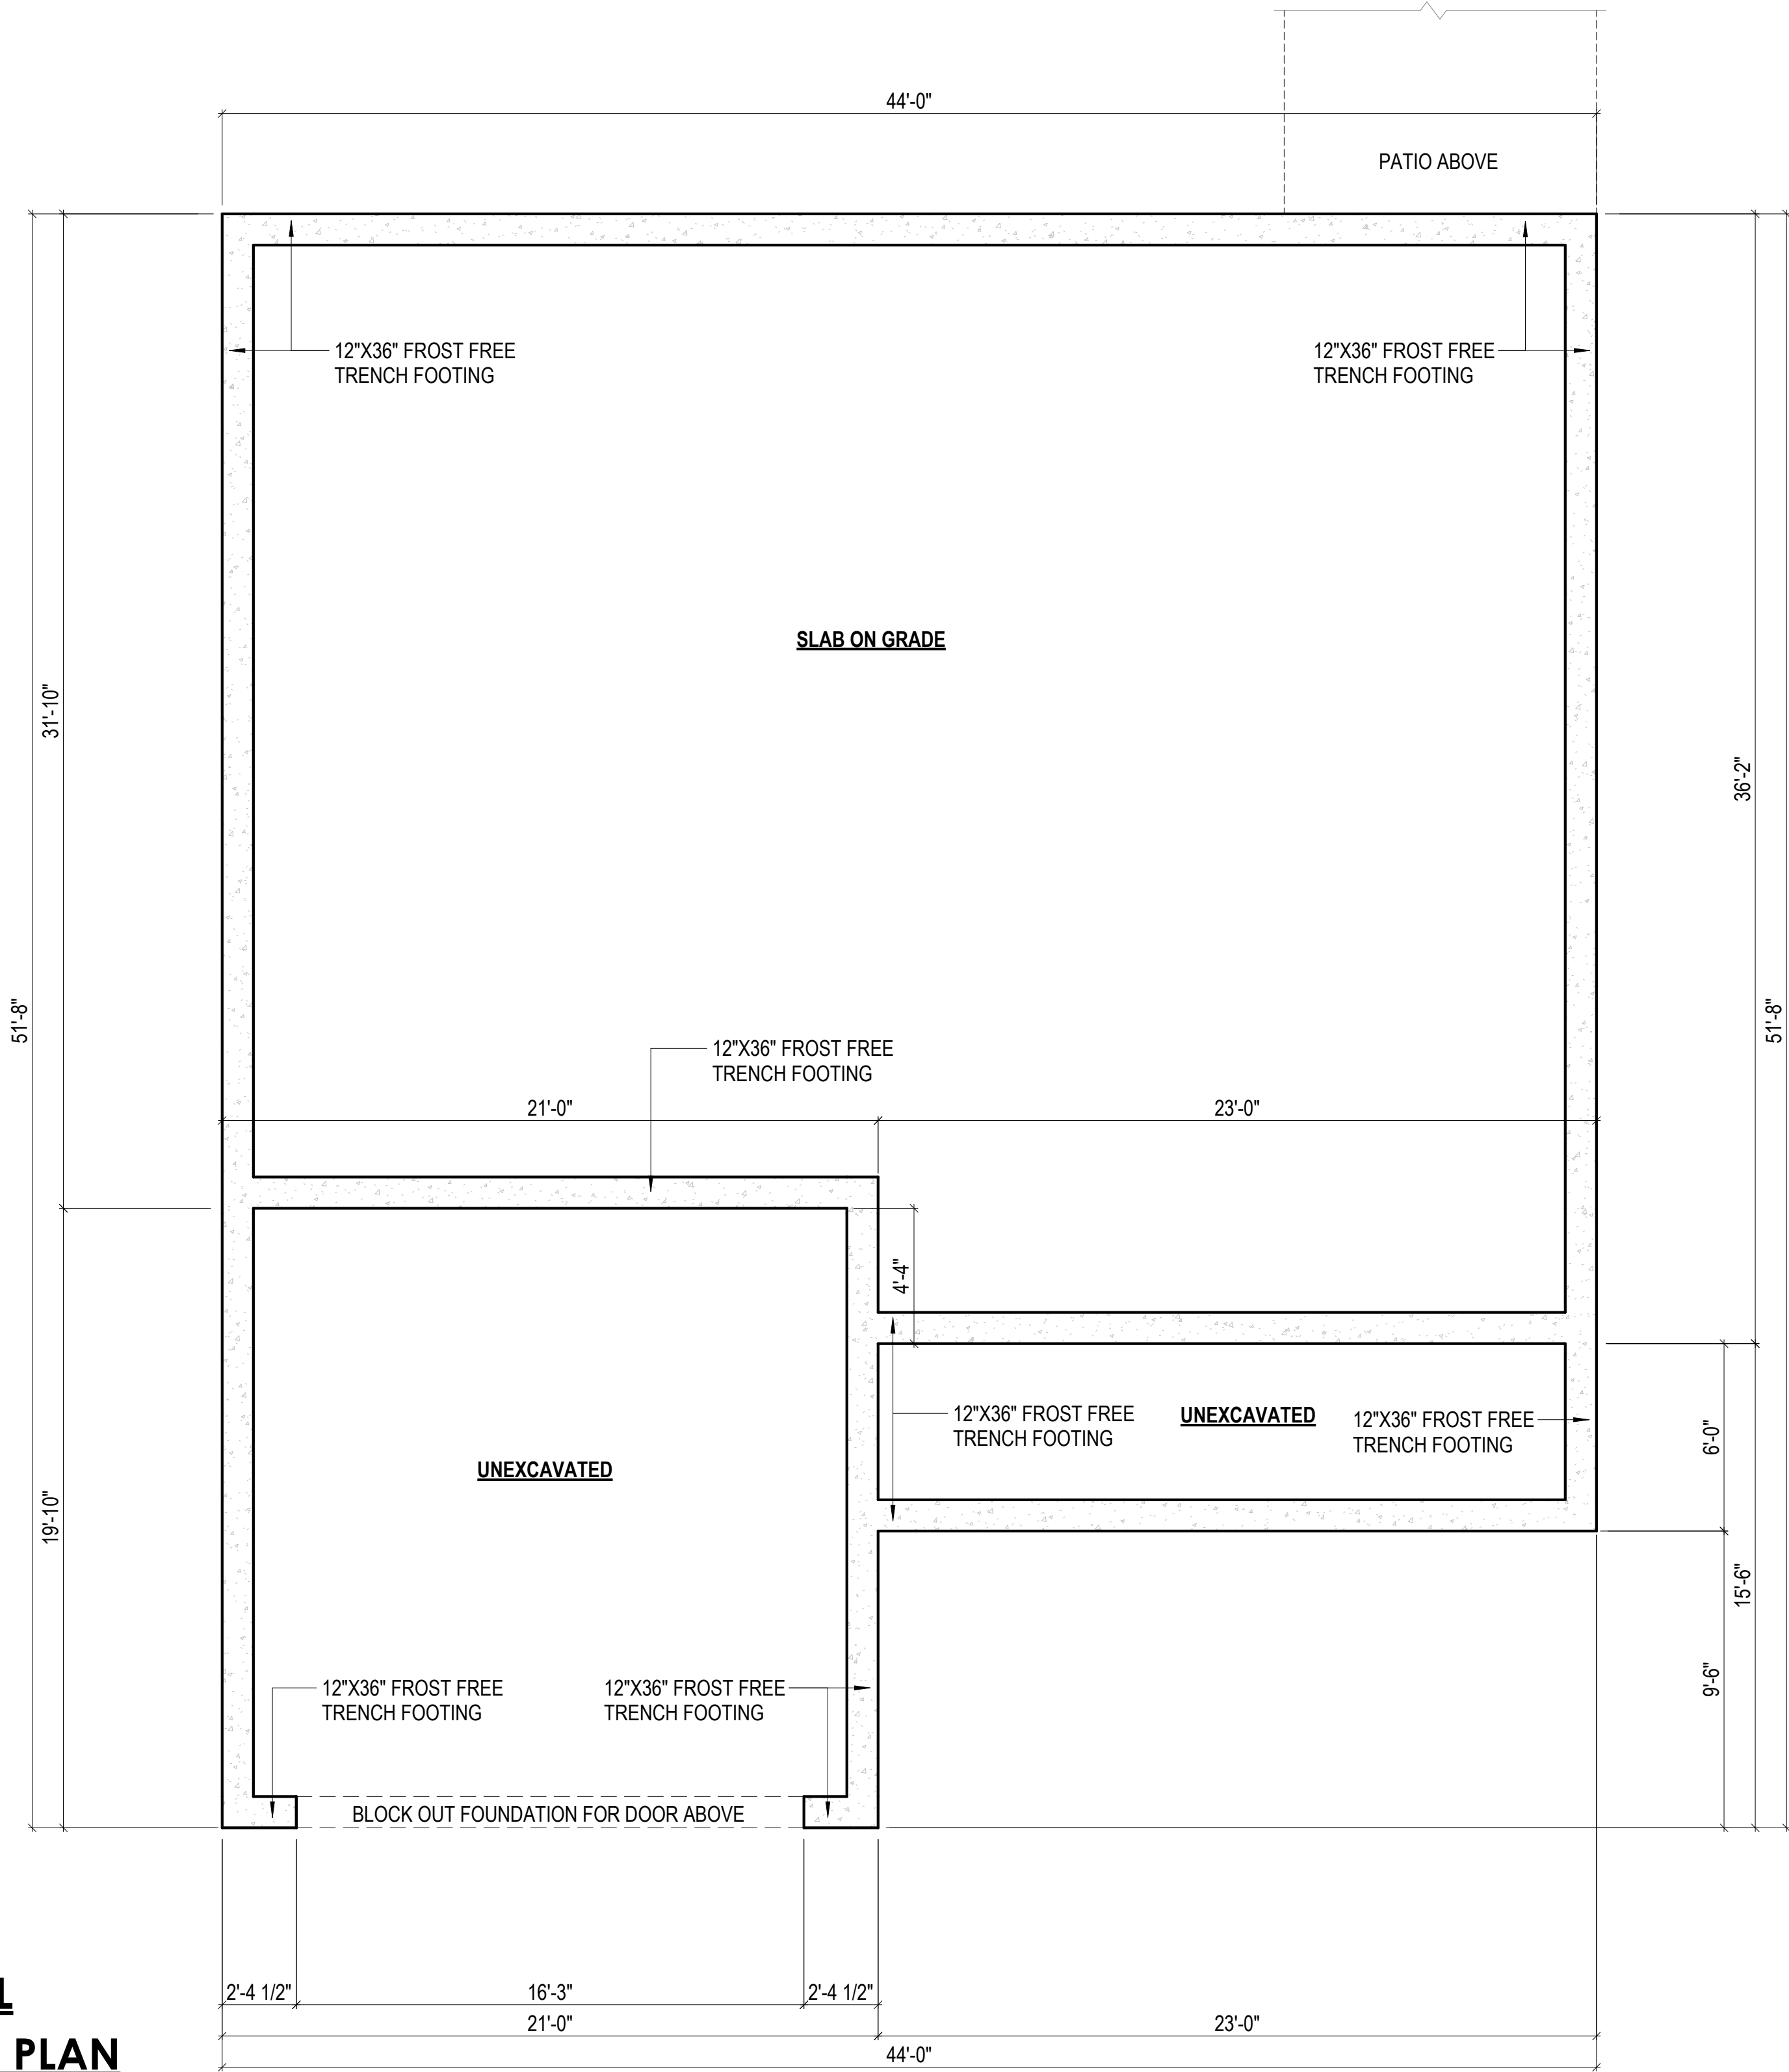

| REVISION TABLE | NUMBER | DATE | REVISED BY | DESCRIPTION |
|----------------|--------|------|------------|-------------|
|                |        |      |            |             |
|                |        |      |            |             |
|                |        |      |            |             |
|                |        |      |            |             |
|                |        |      |            |             |
|                |        |      |            |             |

These drawings are the property of VirtuActive, LLC and are not to be reproduced or used in any manner without the written permission of VirtuActive, LLC. Use of these drawings and concepts contained herein without the written permission of VirtuActive, LLC is prohibited. The contractor, sub-contractor, supplier, and/or homeowner shall verify all dimensions and specifications shown on these drawings. The contractor, sub-contractor, and/or homeowner must check all dimensions and other details prior to construction and be solely responsible for any discrepancies. The contractor, sub-contractor, and/or homeowner are responsible for all code and safety requirements. The contractor, sub-contractor, and/or homeowner are responsible for the safety of all structural members, site suitability, and dimensions shall be verified by the contractor, sub-contractor, supplier, and/or owner.

| PREPARED FOR:                                    | PROJECT LOCATION: |
|--------------------------------------------------|-------------------|
| HOMESTEAD COMMUNITIES<br>RANCH #3<br>Client Name | ADDRESS           |

VIRTUACTIVE  
VirtuActive - 3D Drafting & Design  
1414 North 20th Street, Suite 2, Elkhorn, NE 68022  
www.VirtuActive.com | 402.979.8100

|           |
|-----------|
| DATE:     |
| 10/1/2025 |
| SHEET:    |
| PAGE 5    |



PRELIMINARY PLANS,  
NOT FOR CONSTRUCTION

## DOOR SCHEDULE


| MARK | COUNT | SILL HEIGHT | WIDTH    | HEIGHT  | MODEL |
|------|-------|-------------|----------|---------|-------|
| D0   | 1     | -0' - 4"    | 16' - 0" | 7' - 0" |       |
| D1   | 2     | 0' - 0"     | 3' - 0"  | 6' - 8" |       |
| D2   | 3     | 0' - 0"     | 2' - 8"  | 6' - 8" |       |
| D3   | 1     | 0' - 0"     | 6' - 0"  | 6' - 8" |       |
| D4   | 2     | 0' - 0"     | 2' - 6"  | 6' - 8" |       |
| D5   | 4     | 0' - 0"     | 2' - 4"  | 6' - 8" |       |
| D6   | 1     | 0' - 0"     | 2' - 0"  | 6' - 8" |       |
| D7   | 3     | 0' - 0"     | 5' - 0"  | 6' - 8" |       |

## WINDOW SCHEDULE

| MARK | COUNT | SILL HEIGHT | WIDTH       | HEIGHT       | MODEL |
|------|-------|-------------|-------------|--------------|-------|
| W1   | 2     | 1' - 8 3/4" | 6' - 2 3/4" | 4' - 11 3/4" |       |
| W2   | 2     | 1' - 8 3/4" | 3' - 1 3/4" | 4' - 11 3/4" |       |
| W3   | 1     | 3' - 2 3/4" | 3' - 1 3/4" | 3' - 5 3/4"  |       |

## FOUNDATION & FRAMING NOTES

1. All structural members and framing members shall be confirmed by contractor, sub-contractor, and/or supplier for size, spacing, and species to verify they meet local code requirements.
2. All exterior framing dimensions are to exterior face of sheathing.
3. All interior framing dimensions to framing edge, unless otherwise noted.
4. 12" x Min. 36" below grade poured concrete foundation walls, unless otherwise noted.
5. 2x6 exterior and 2x4 interior walls, unless otherwise noted.
6. All exterior headers shall be (2) 2x12, unless otherwise noted.
7. Door sizes noted as feet and inches.
8. Window sizes noted as inches. Contractor, sub-contractor, and/or suppliers to confirm window openings for egress, min. light, min. height, and ventilation requirements. Contractor and/or sub-contractor to go off of supplier provided rough opening sheet for all rough openings & sizes.
9. Ceiling Heights: 8'-0" Main Floor.
10. Allow for at least 3.5" from interior door rough openings to wall.
11. All angled walls are 45°, unless otherwise noted.
12. All centerline dimensions for fixtures should be double checked for field accuracy.
13. Wall bracing method = CS-WSP

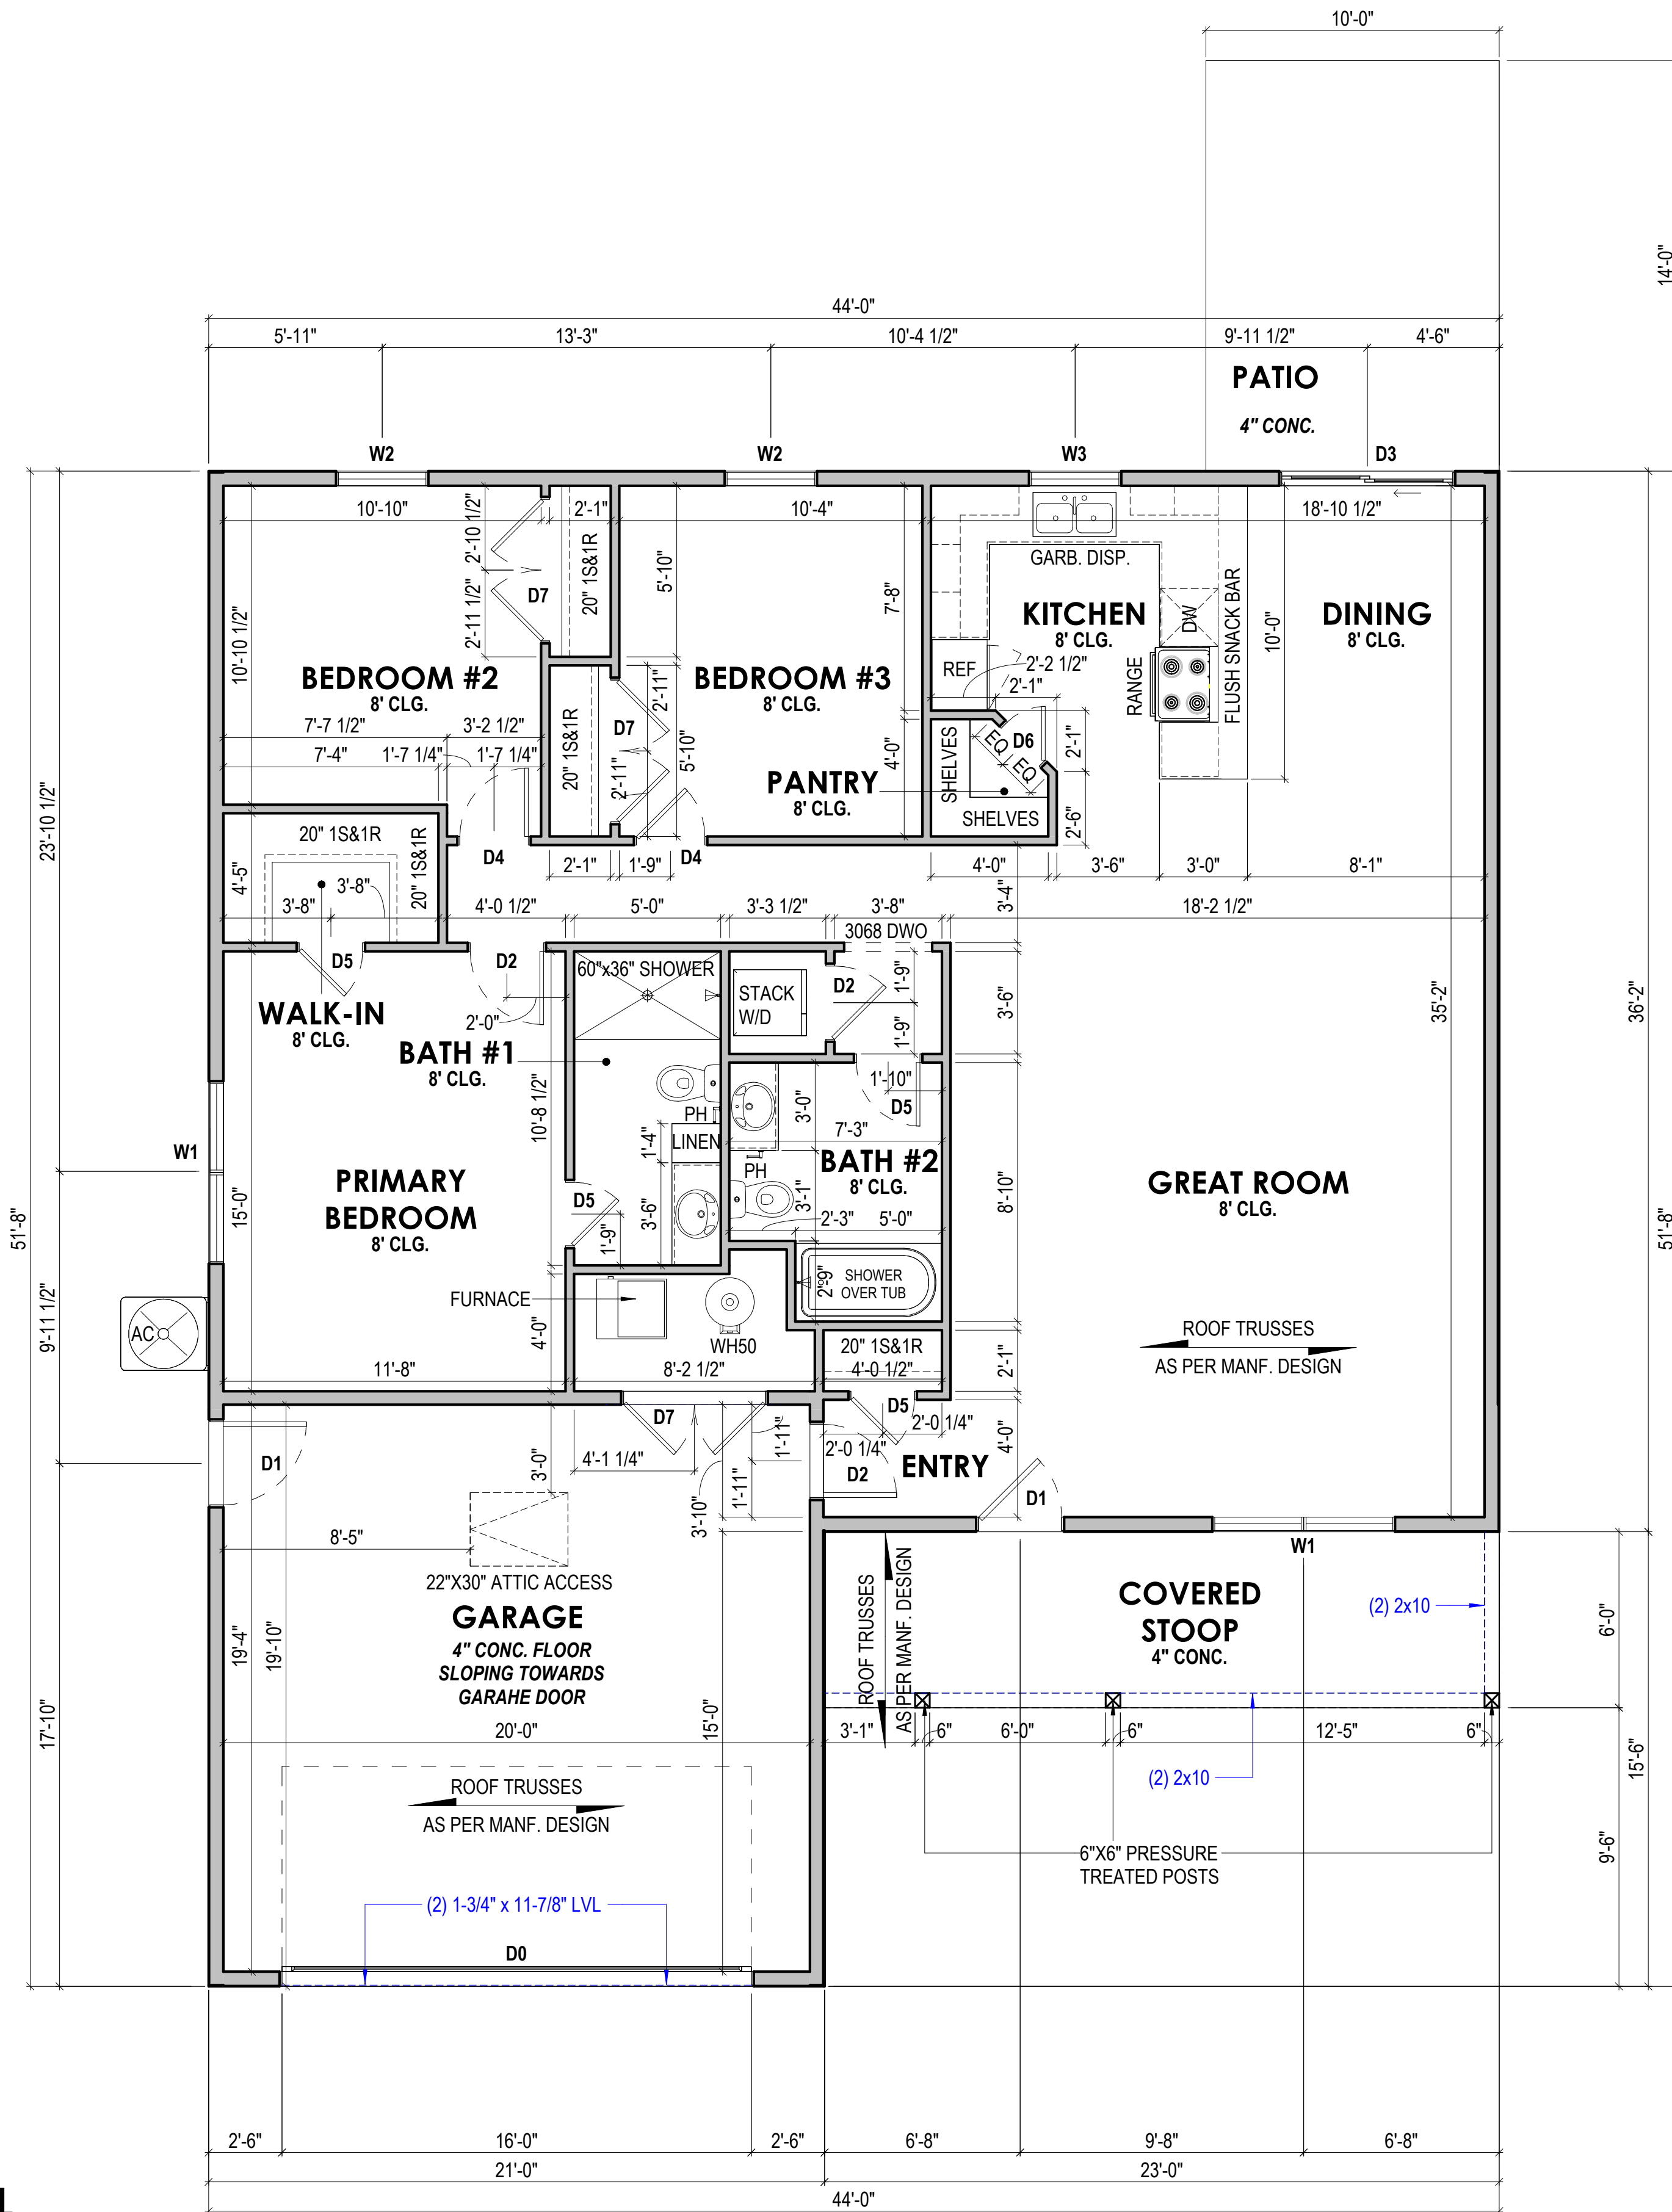

## TRANSITIONAL

## MAIN LEVEL FLOOR PLAN

$$1/4'' = 1'-0''$$

|                         |         |
|-------------------------|---------|
| <b>FINISHED SQ. FT.</b> |         |
| MAIN LEVEL              | 1502 SF |
| TOTALS                  | 1502 SF |

| <b>UNFINISHED SQ. FT.</b> |               |
|---------------------------|---------------|
| COVERED STOOP             | 138 SF        |
| GARAGE                    | 414 SF        |
| PATIO                     | 140 SF        |
| <b>TOTALS</b>             | <b>692 SF</b> |



| REVISION TABLE |      |                         |
|----------------|------|-------------------------|
| NUMBER         | DATE | REVISION BY DESCRIPTION |
|                |      |                         |
|                |      |                         |
|                |      |                         |
|                |      |                         |

[illegible]

PROJECT LOCATION:

ADDRESS

PREPARED FOR:

HOMESTEAD COMMUNITIES  
RANCH #3

Client Name

VIRTUACTIVE

**VirtuActive - 3D Drafting & Design**  
414 North 205th Street, Suite 2, Elkhorn, NE 68022

www.VirtuActive.com | 402.979.8100

DATE:

10/1/2025


SHEET:

PAGE 6



VIRTUACTIVE


PRELIMINARY PLANS,  
NOT FOR CONSTRUCTION

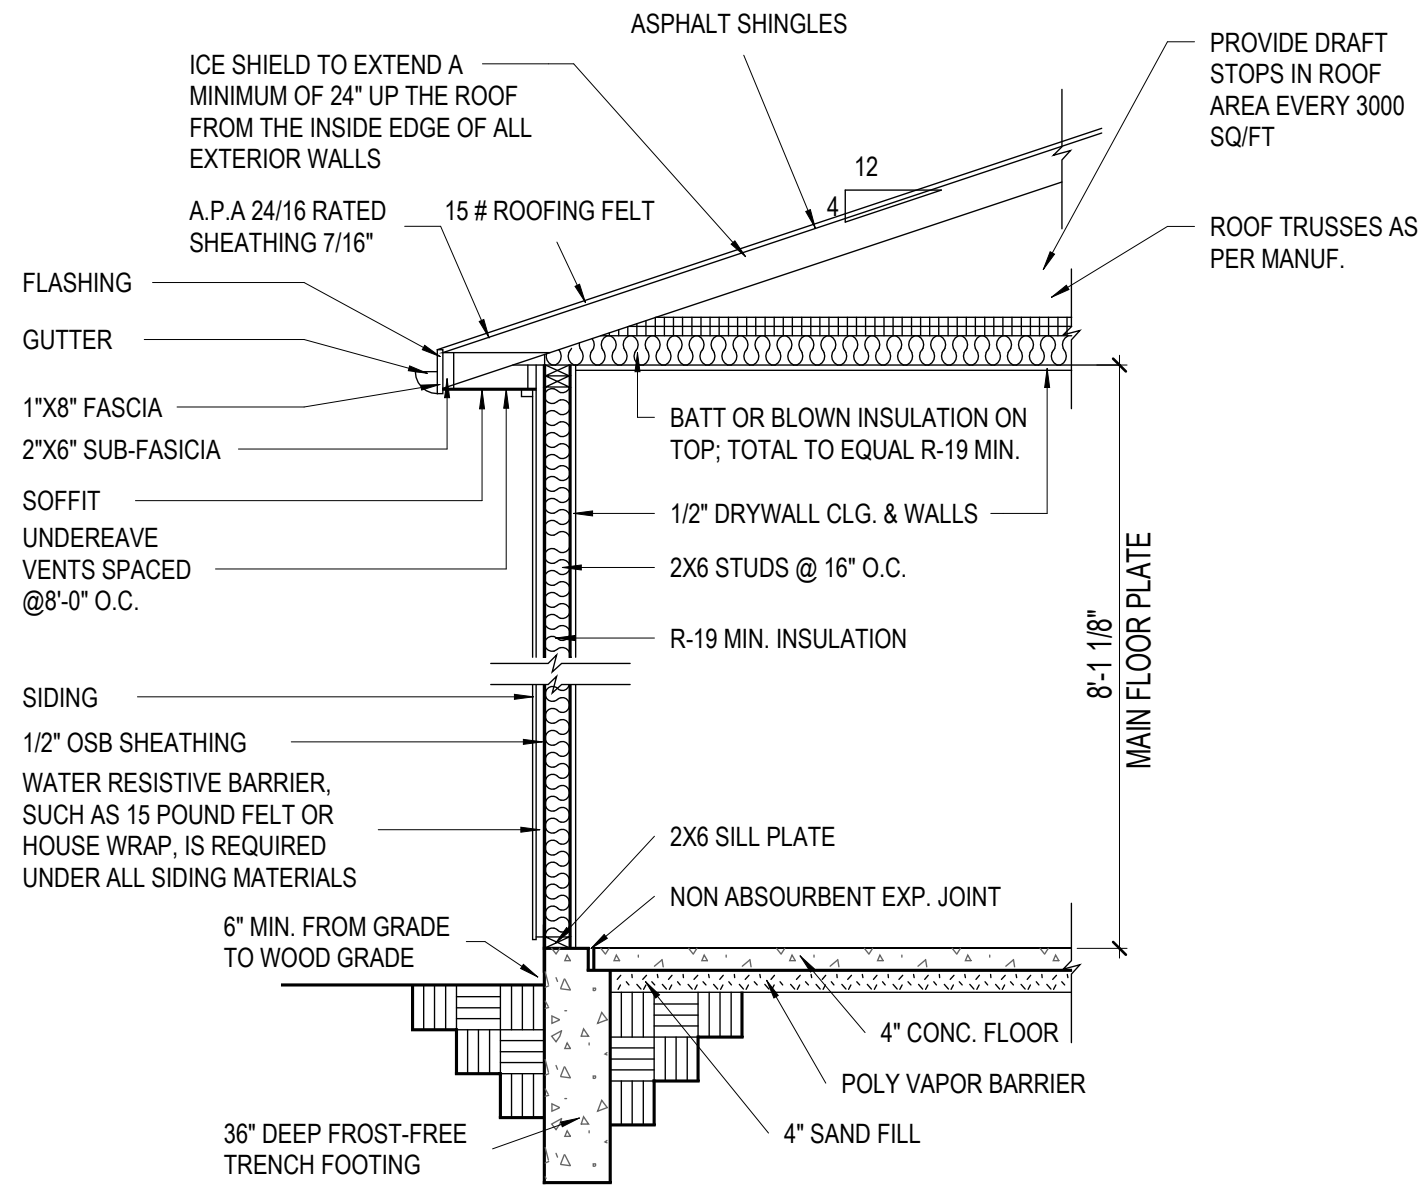

(SEE WALK-OUT WALL SECTION FOR REBAR INFORMATION)

2 **TYPICAL GARAGE & WALL SECTION**

3/8" = 1'-0"

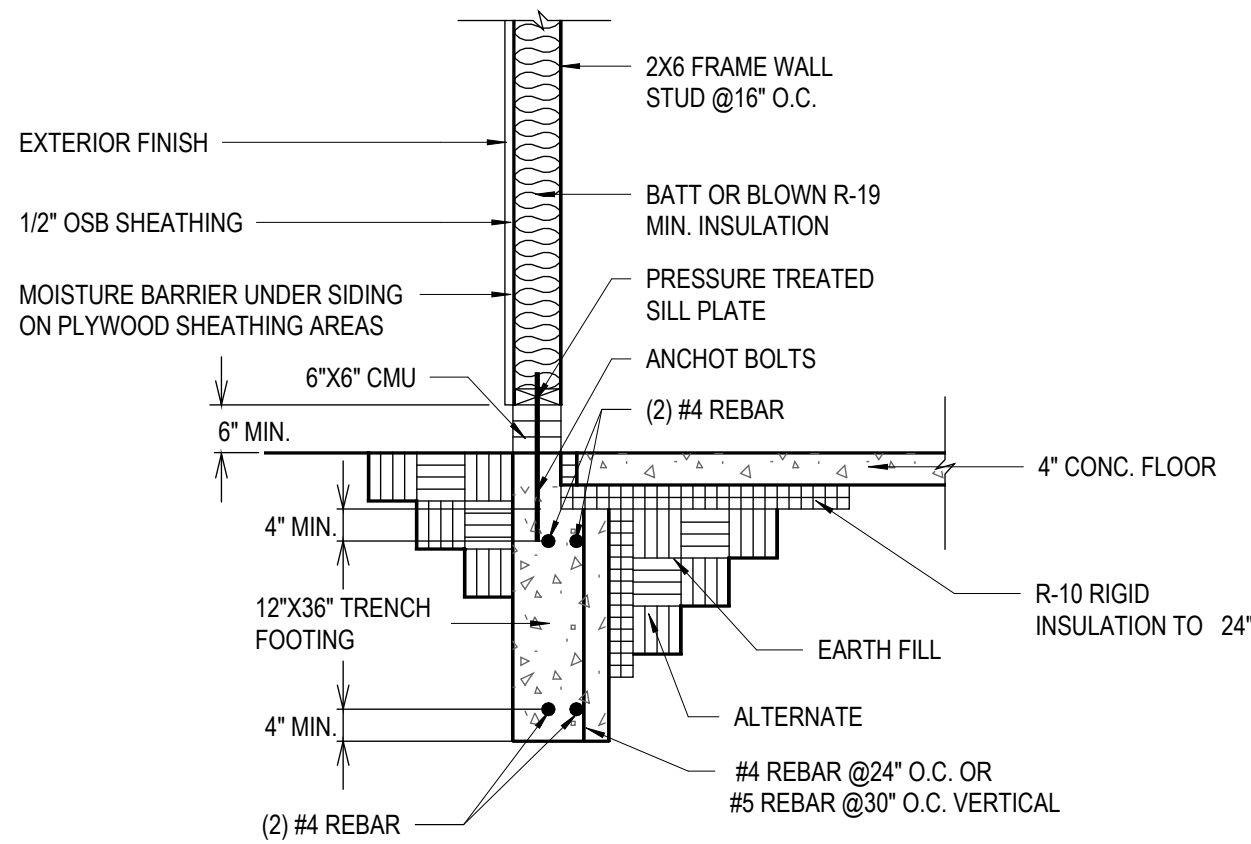

3 **GARAGE TO HOUSE WALL SECTION**


1/2" = 1'-0"

- ROOF TRUSSES PER MANUFACTURER
- 1'-4" OVERHANG (TYP.)
- GABLE 1'-4" OVERHANG

1

**TRANSITIONAL  
ROOF PLAN**

1/4" = 1'-0"

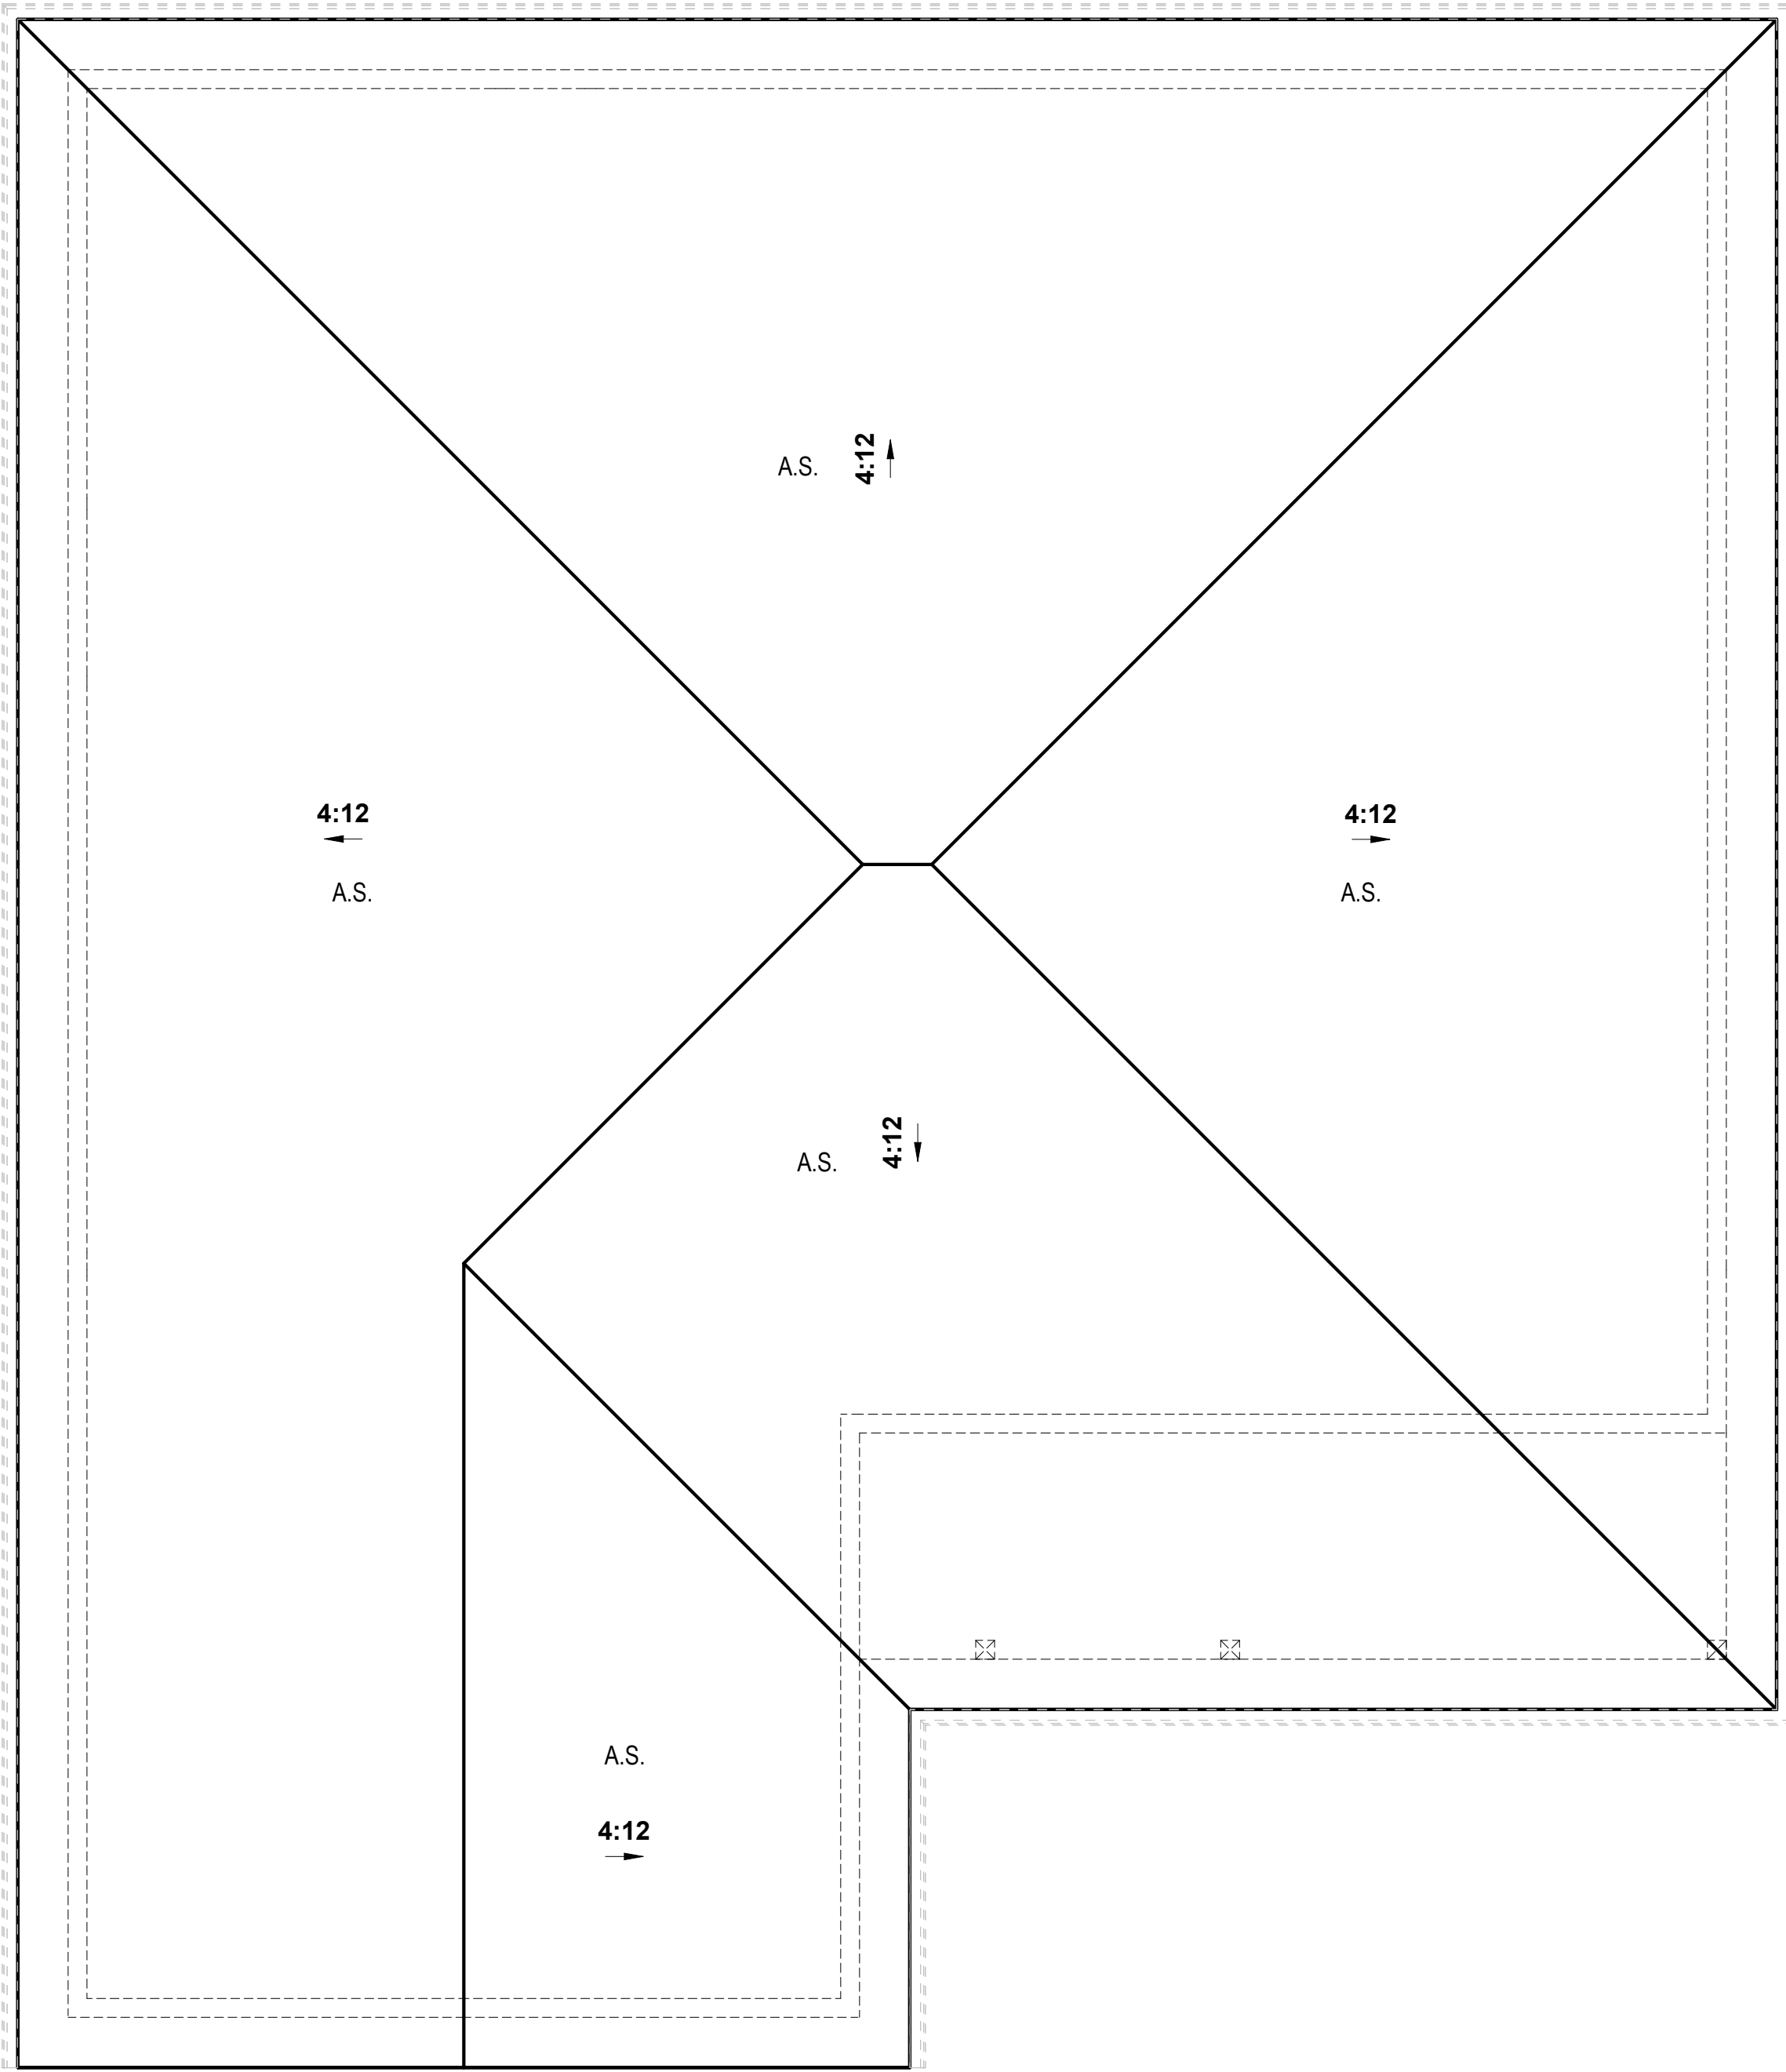

These drawings are the property of VirtuActive, LLC and are not to be reproduced, copied, or used in any way without the written permission of VirtuActive, LLC. Use of these drawings and concepts contained herein without the written permission of VirtuActive, LLC is prohibited. The contractor, sub-contractor, supplier, and/or homeowner shall verify all dimensions and specifications shown on these drawings. The contractor, sub-contractor, supplier, and/or homeowner must check all dimensions and other details prior to construction and be solely responsible for any errors or omissions. VirtuActive, LLC and its representatives are not responsible for any errors or omissions on the job due to lack of knowledge or lack of plan detail from the sub-contractor, supplier, and/or homeowner. Dimensions shall be verified by the contractor, sub-contractor, supplier, and/or owner.

PROJECT LOCATION:  
ADDRESS

PREPARED FOR:  
HOMESTEAD COMMUNITIES  
RANCH #3  
Client Name

VIRTUACTIVE  
VirtuActive - 3D Drafting & Design  
1414 North 20th Street, Suite 2, Elkhorn, NE 68022  
www.VirtuActive.com | 402.979.8100


DATE:  
10/1/2025  
SHEET:  
PAGE 7





PRELIMINARY PLANS,  
NOT FOR CONSTRUCTION


| ELECTRICAL - DATA - AUDIO LEGEND                                                                         |                                                       |
|----------------------------------------------------------------------------------------------------------|-------------------------------------------------------|
| SYMBOL                                                                                                   | DESCRIPTION                                           |
|                         | 110V Receptacles: Duplex                              |
|                         | 110V Receptacles: GFCI                                |
|                         | 110V Single Receptacle: Microwave                     |
|                         | 110V Single Receptacle: Refrigerator                  |
|                         | 220V/240V Receptacles: Clothes Dryer                  |
|                         | 220V/240V Receptacles: Oven                           |
|                         | Ceiling Fan w/ Light                                  |
|                         | CO-Smoke Detector: Ceiling Mounted                    |
|                         | Special Purpose Duplex Receptacle: Dishwasher         |
|                         | Ceiling Mounted 110V Receptacle, Garage Door Opener   |
|                         | Ceiling Mounted Light Fixture: Fixture                |
|                         | Ceiling Mounted Light Fixture: Keyless                |
|                         | Ceiling Mounted Light Fixture: Wafers w/ weatherproof |
|                         | Ceiling Mounted Light Fixture: Recessed               |
|                         | Ceiling Mounted Light Fixture: Surface/Flushmount     |
|                         | 110V Single Receptacles: Garbage Disposal             |
|                         | Special Purpose Single Receptacle: Washing Machine    |
|                        | Switch: 3-Way                                         |
|                       | Switch: Single Pole                                   |
|                       | Smoke Detector: Ceiling Mounted                       |
|                       | Ventilation Fans: Ceiling Mounted                     |
|                       | Wall Mounted Light Fixture: Triple                    |
| CONTRACTOR, ELECTRICIAN, & HOMEOWNER TO SITE VERIFY FIXTURE TYPE, LOCATION, QUANTITY, & COLOR COMPLIANCE |                                                       |

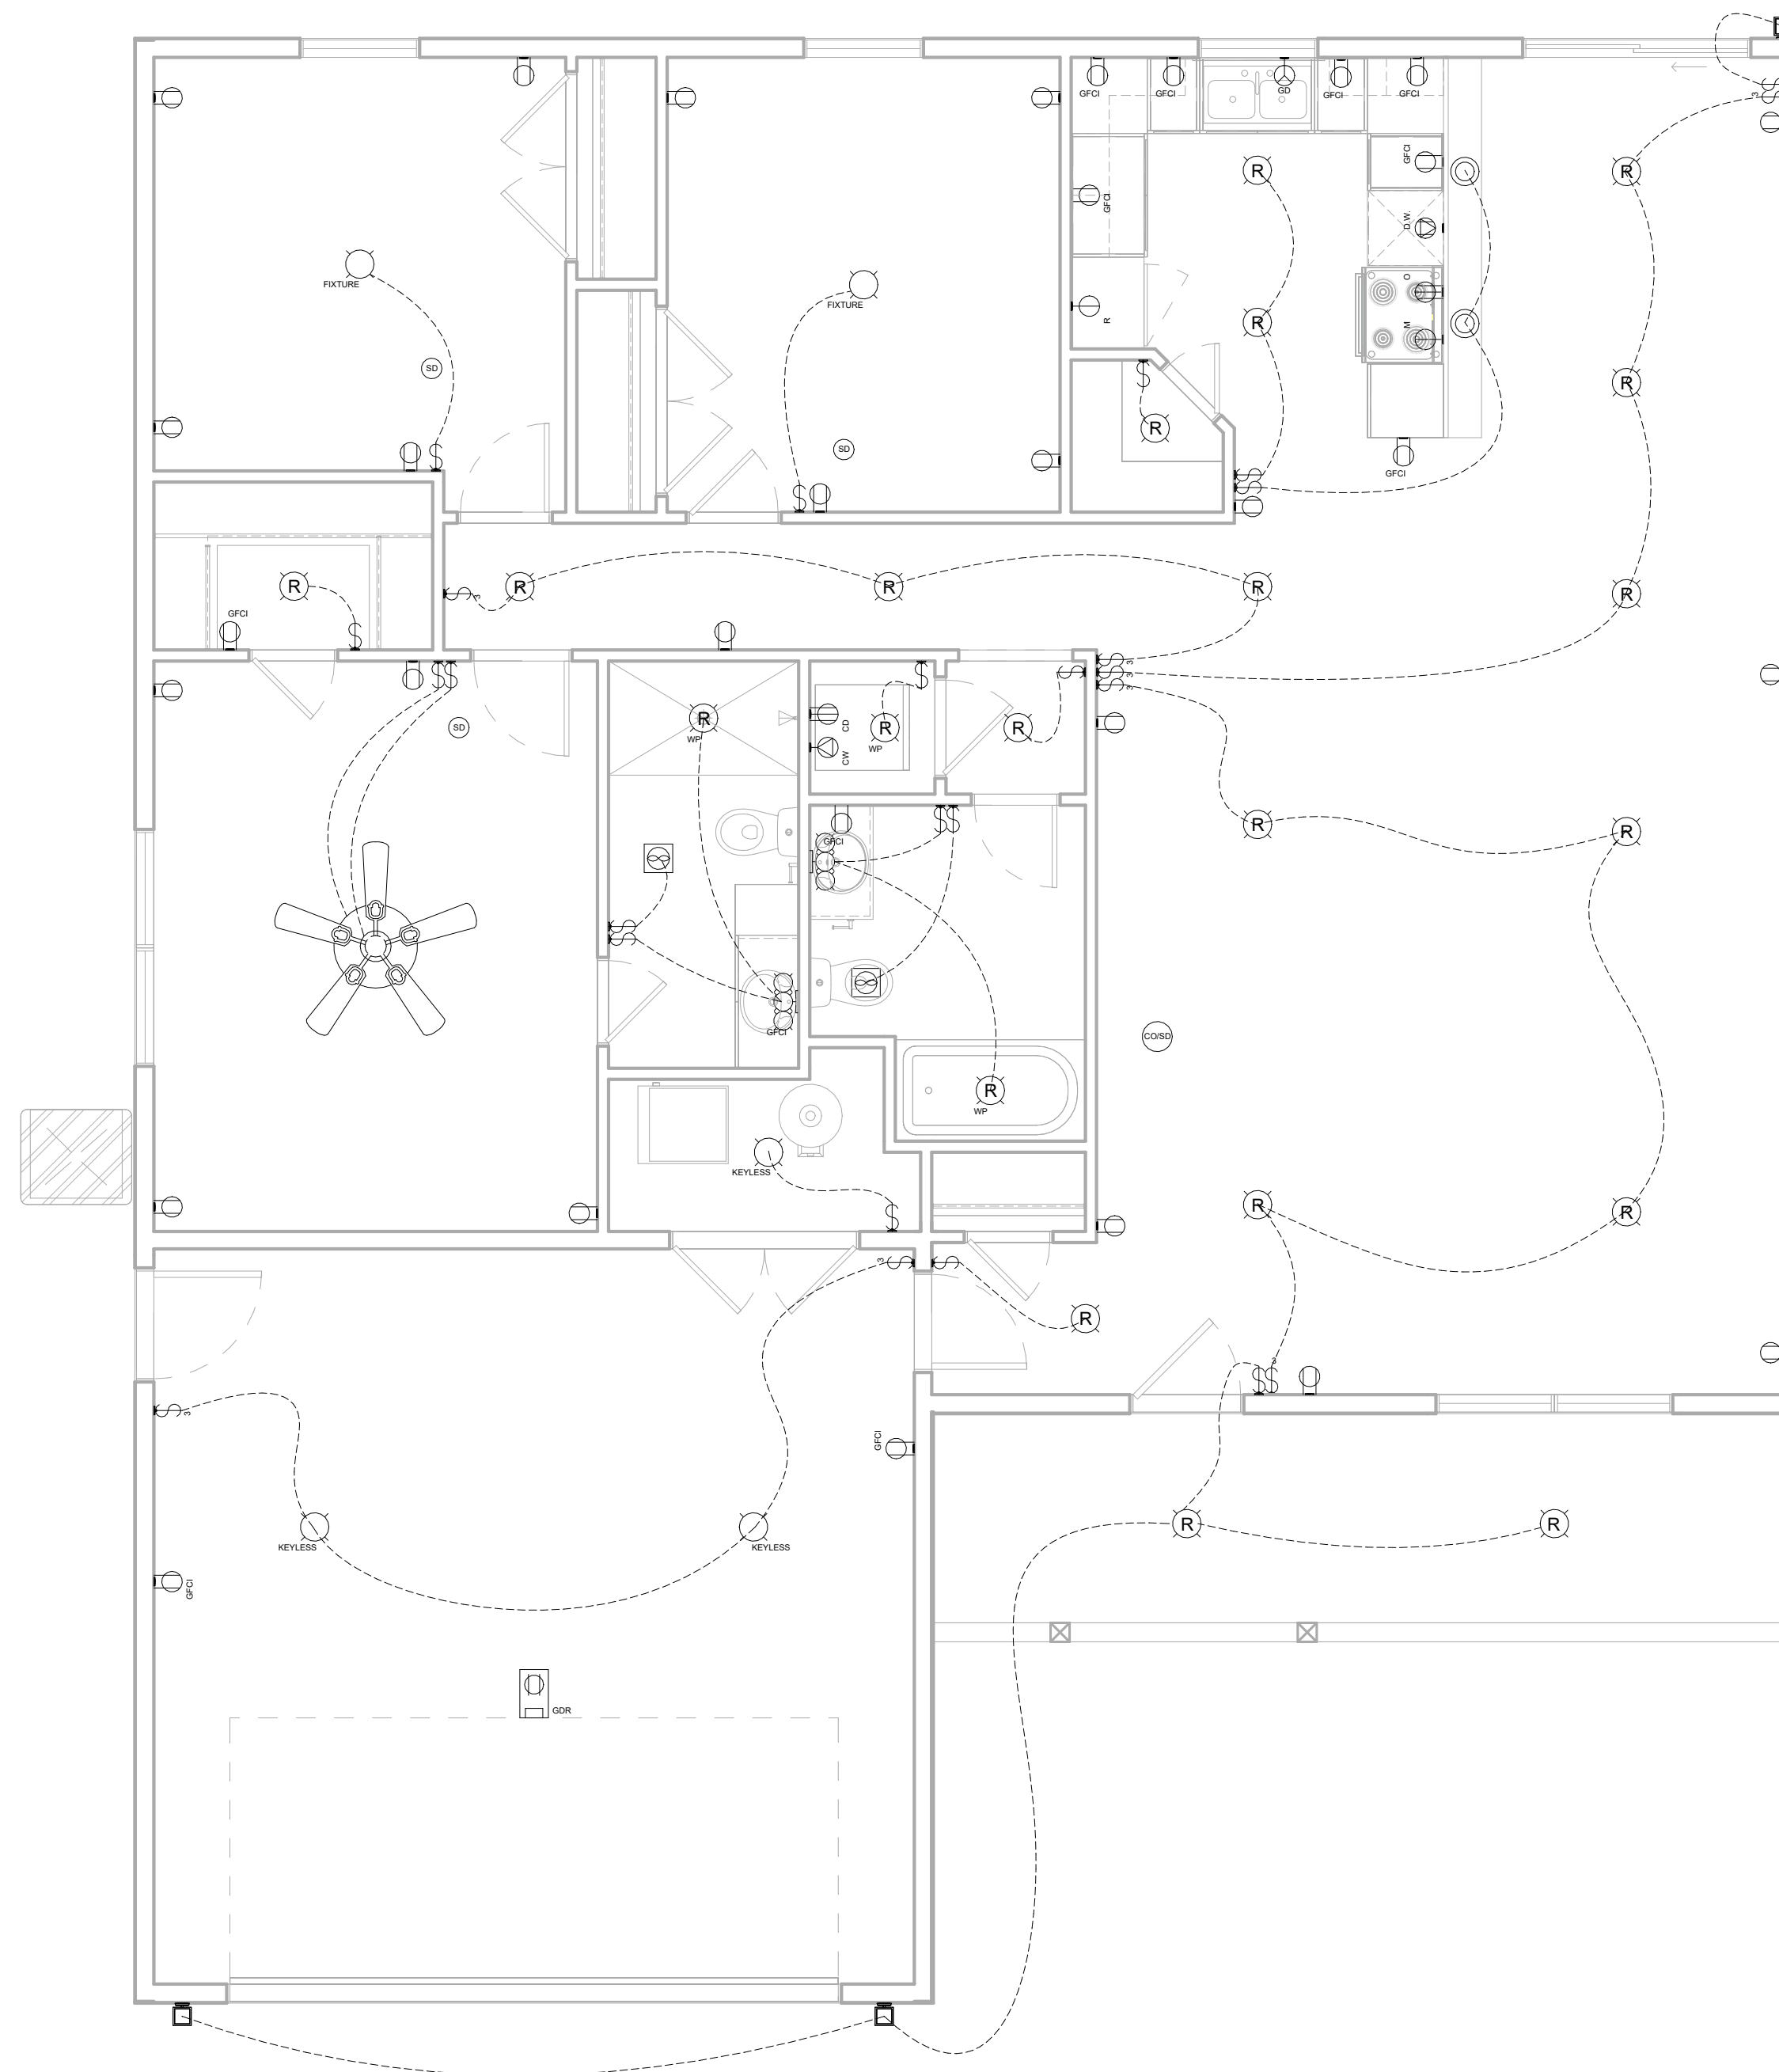

## TRANSITIONAL

## MAIN LEVEL ELECTRICAL PLAN

$$1/4'' = 1'-0''$$

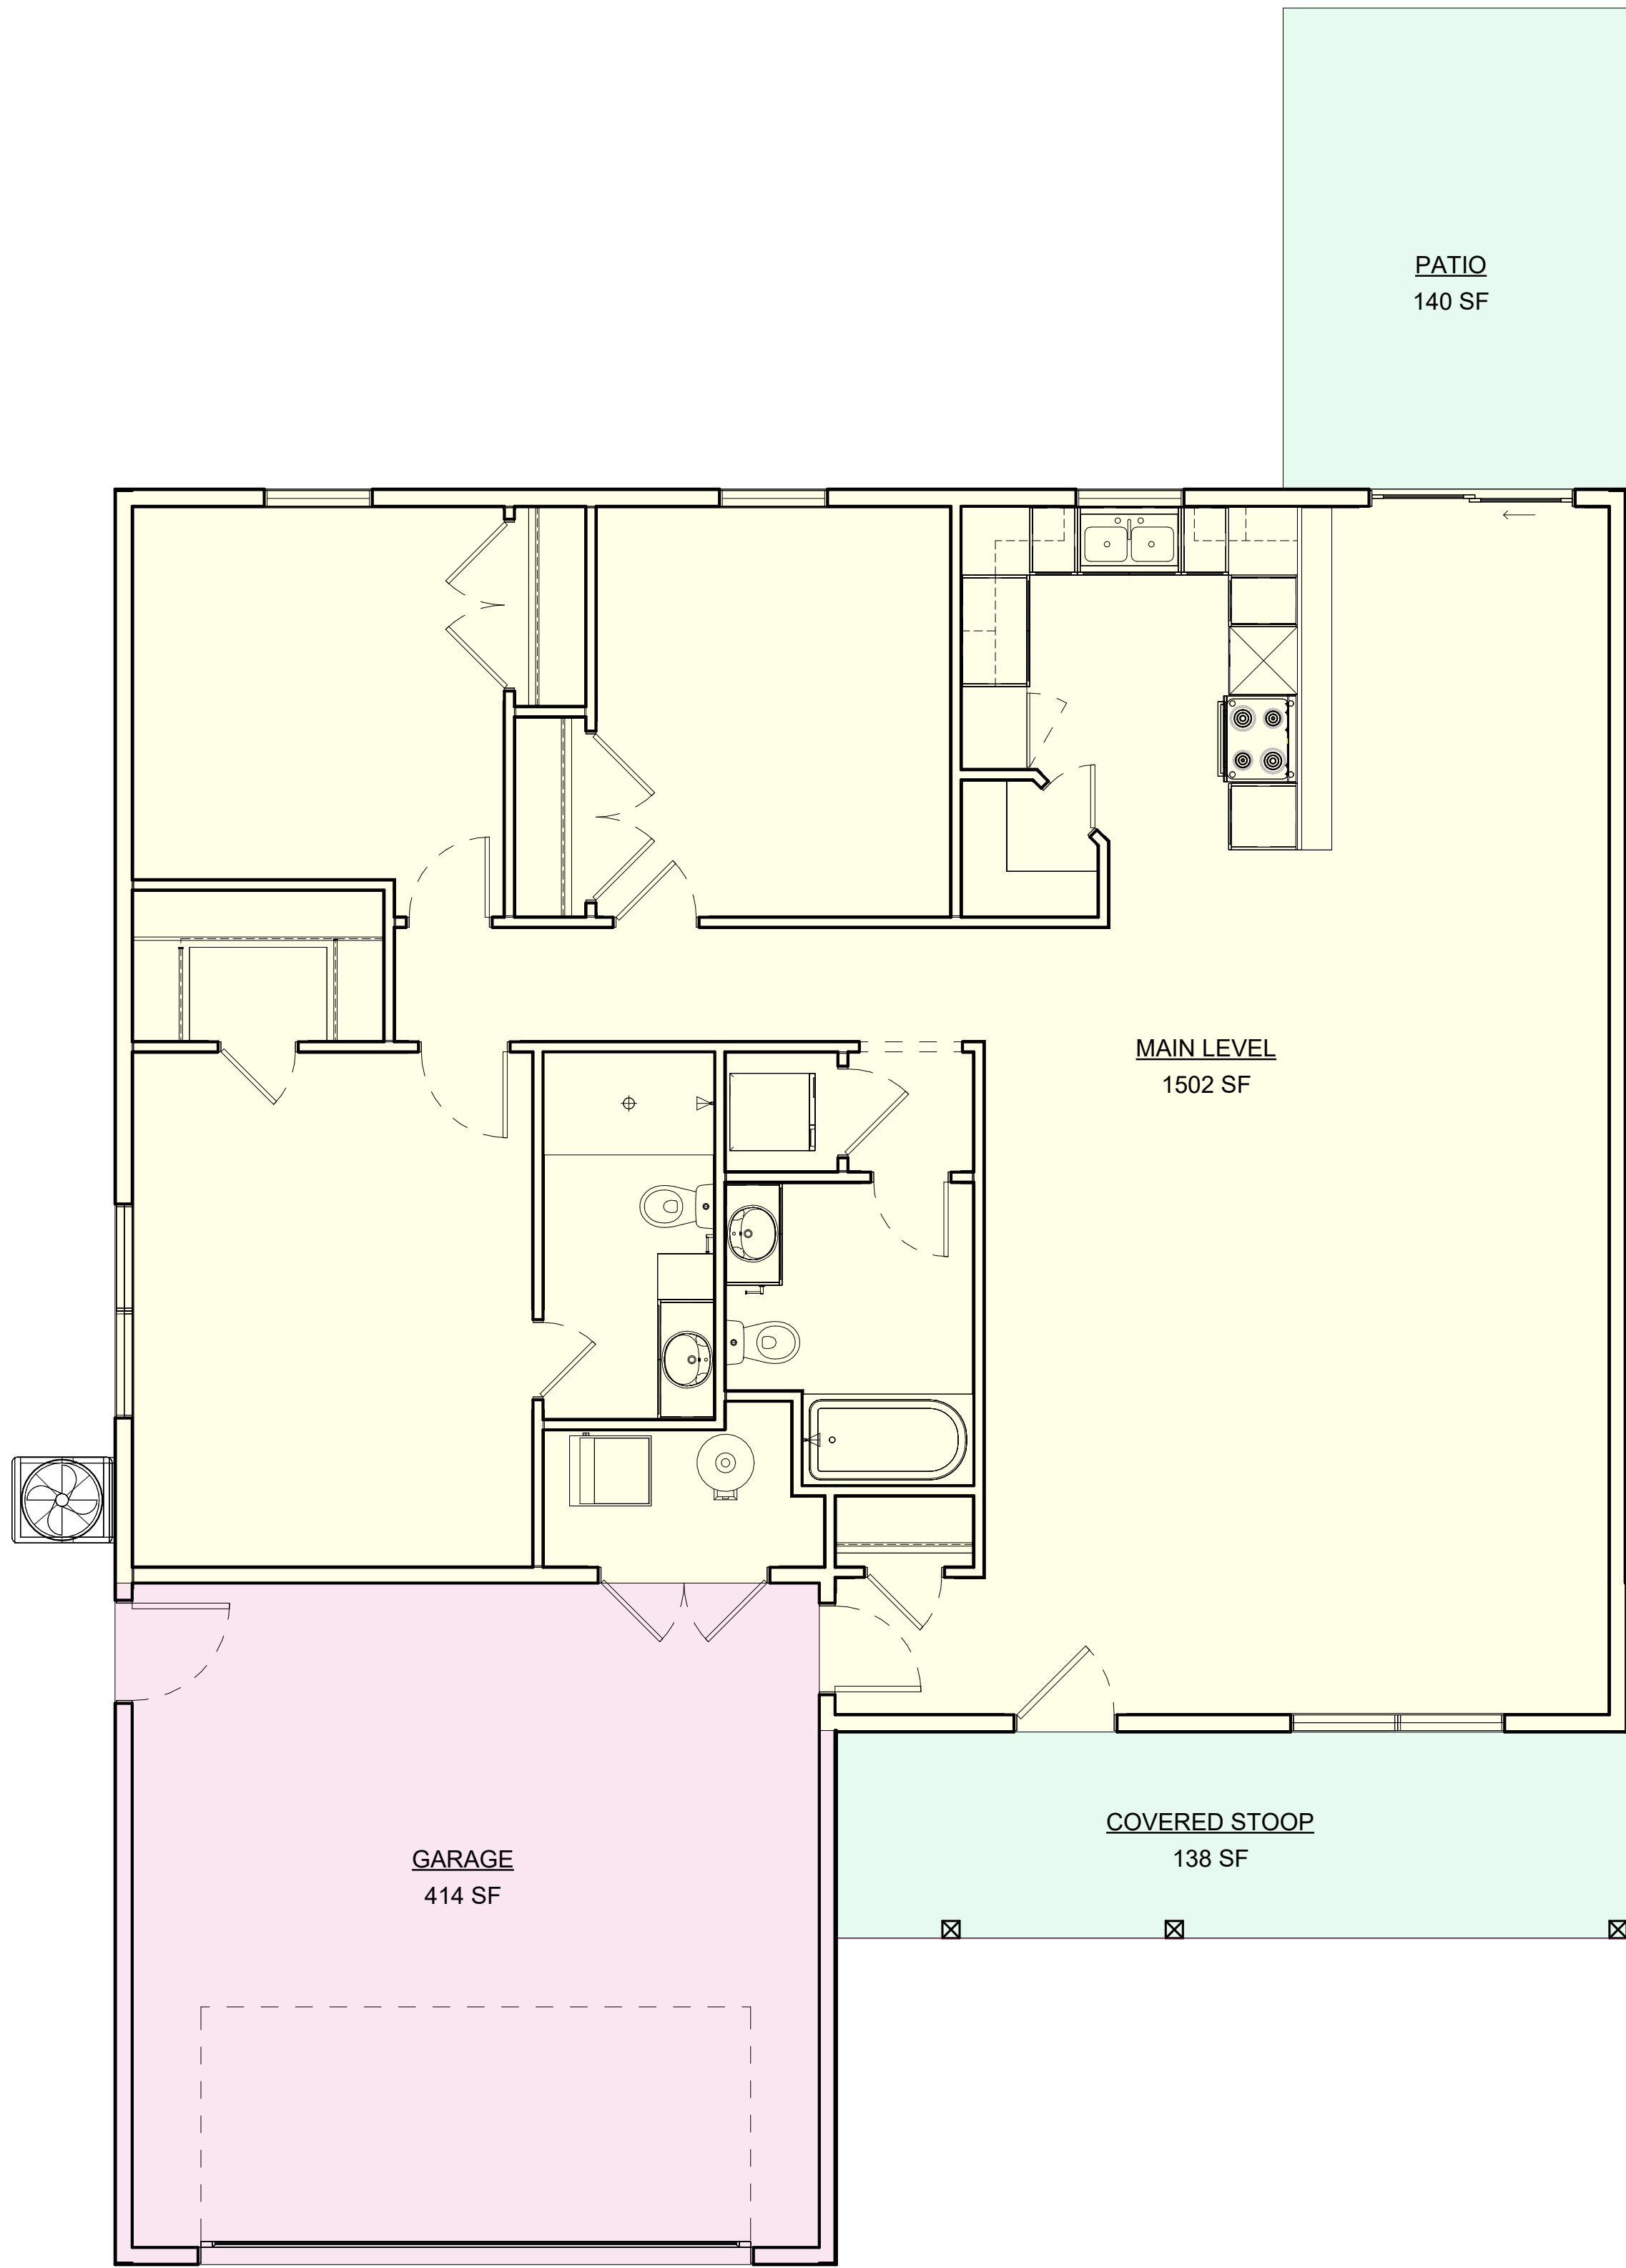

1

TRANSITIONAL  
MAIN LEVEL AREA PLAN  
1/4" = 1'-0"

These drawings are the property of VirtuActive, LLC and are not to be reproduced or used for any other project without the written permission of VirtuActive, LLC. Use of these drawings and concepts contained herein without the written permission of VirtuActive, LLC is prohibited. The contractor, sub-contractor, supplier, and/or homeowner shall verify all dimensions and materials shown on these drawings. The contractor, sub-contractor, supplier, and/or homeowner must check all dimensions and other details prior to construction and be solely responsible for any discrepancies. VirtuActive, LLC and its representatives are not responsible for any errors or omissions on these drawings due to lack of knowledge or lack of plan detail from the sub-contractor, supplier, and/or owner.

| PREPARED FOR:                                    | PROJECT LOCATION: |
|--------------------------------------------------|-------------------|
| HOMESTEAD COMMUNITIES<br>RANCH #3<br>Client Name | ADDRESS           |

| REVISION TABLE | NUMBER | DATE | REVISOR | DESCRIPTION |
|----------------|--------|------|---------|-------------|
|                |        |      |         |             |
|                |        |      |         |             |
|                |        |      |         |             |
|                |        |      |         |             |
|                |        |      |         |             |